
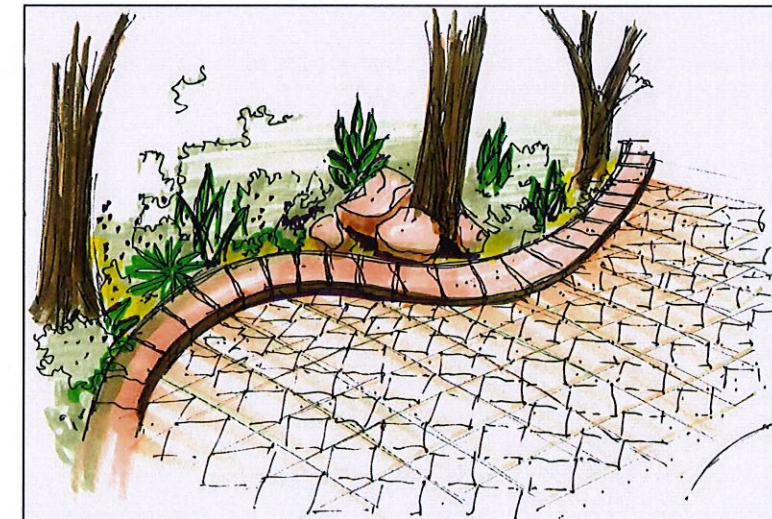



AQABA SPECIAL ECONOMIC ZONE AUTHORITY

عطاء رقم (00/هـ/2025) والخاص بإنشاء حديقة عامة على قطعة أرض رقم 140
في المنطقة السكنية الثالثة

THIRD RESIDENTIAL DISTRICT GARDEN NO.140

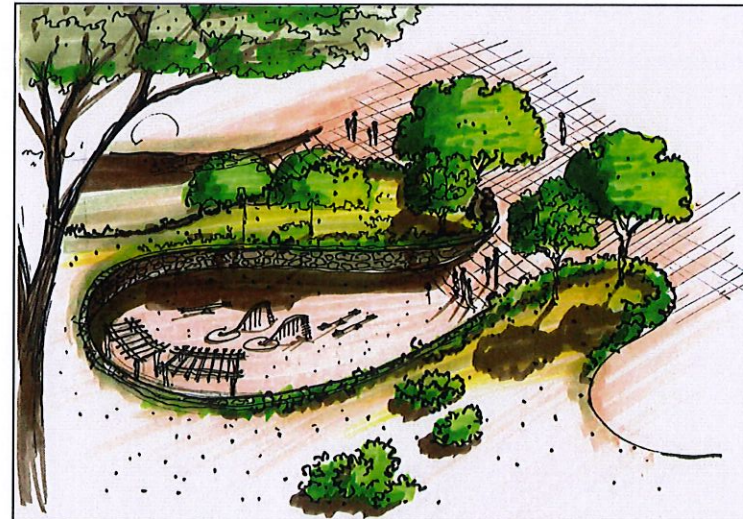

THIRD RESIDENTIAL DISTRICT


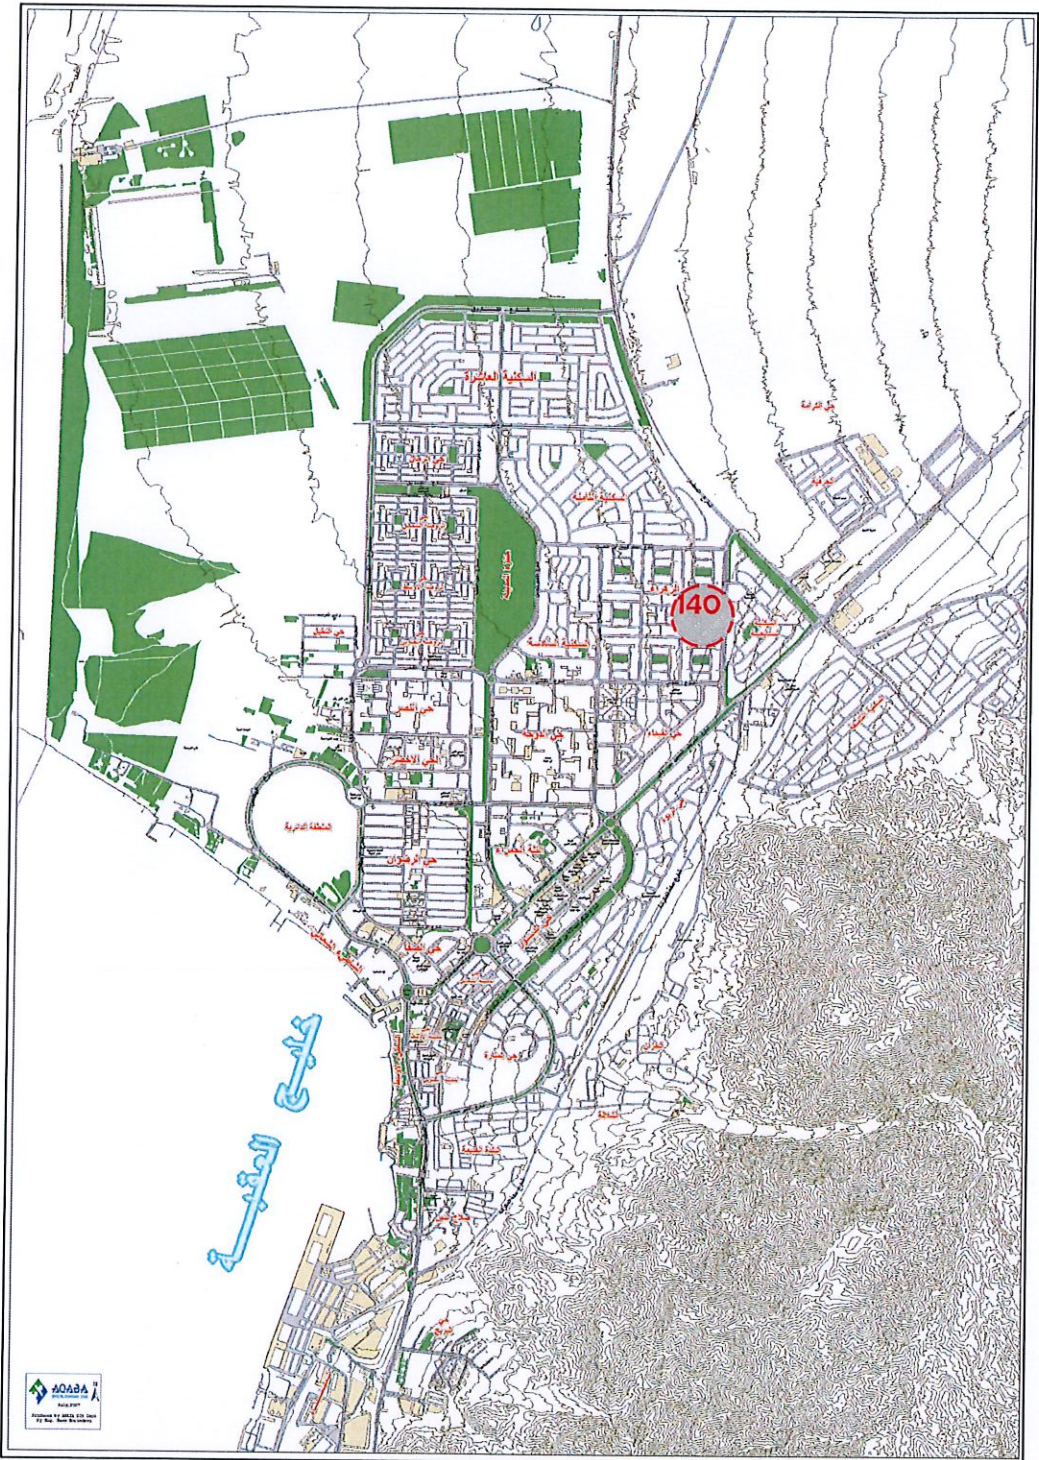


AQABA GARDEN NO. 140

INDEX

NO.	ARCHITECTURAL
A-00a	COVER SHEET
A-00b	LIST OF DRAWINGS
A-001	TOPOGRAPHIC PLAN
A-002	MASTER PLAN
A-003	FURNITURE & REFERENCE PLANS
A-004	AFMCO BUILDING
AD-001	GENERAL DETAILS 1
AD-002	GENERAL DETAILS 2
AD-003	GENERAL DETAILS 3
AD-004	GENERAL DETAILS 4
AD-005	LAYOUT, FINISHING & FURNITURE DETAILS
AD-006	SPORTS FIELD DETAILS
SD-001	PERGOLA, STAIRS & DECORATIVE FOUNTAIN
E-001	ELECTRICAL DETAILS
M-001	WATER PLAN
M-002	DRAINAGE PLAN



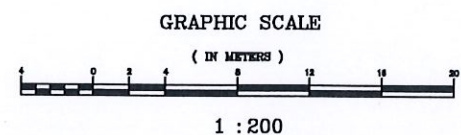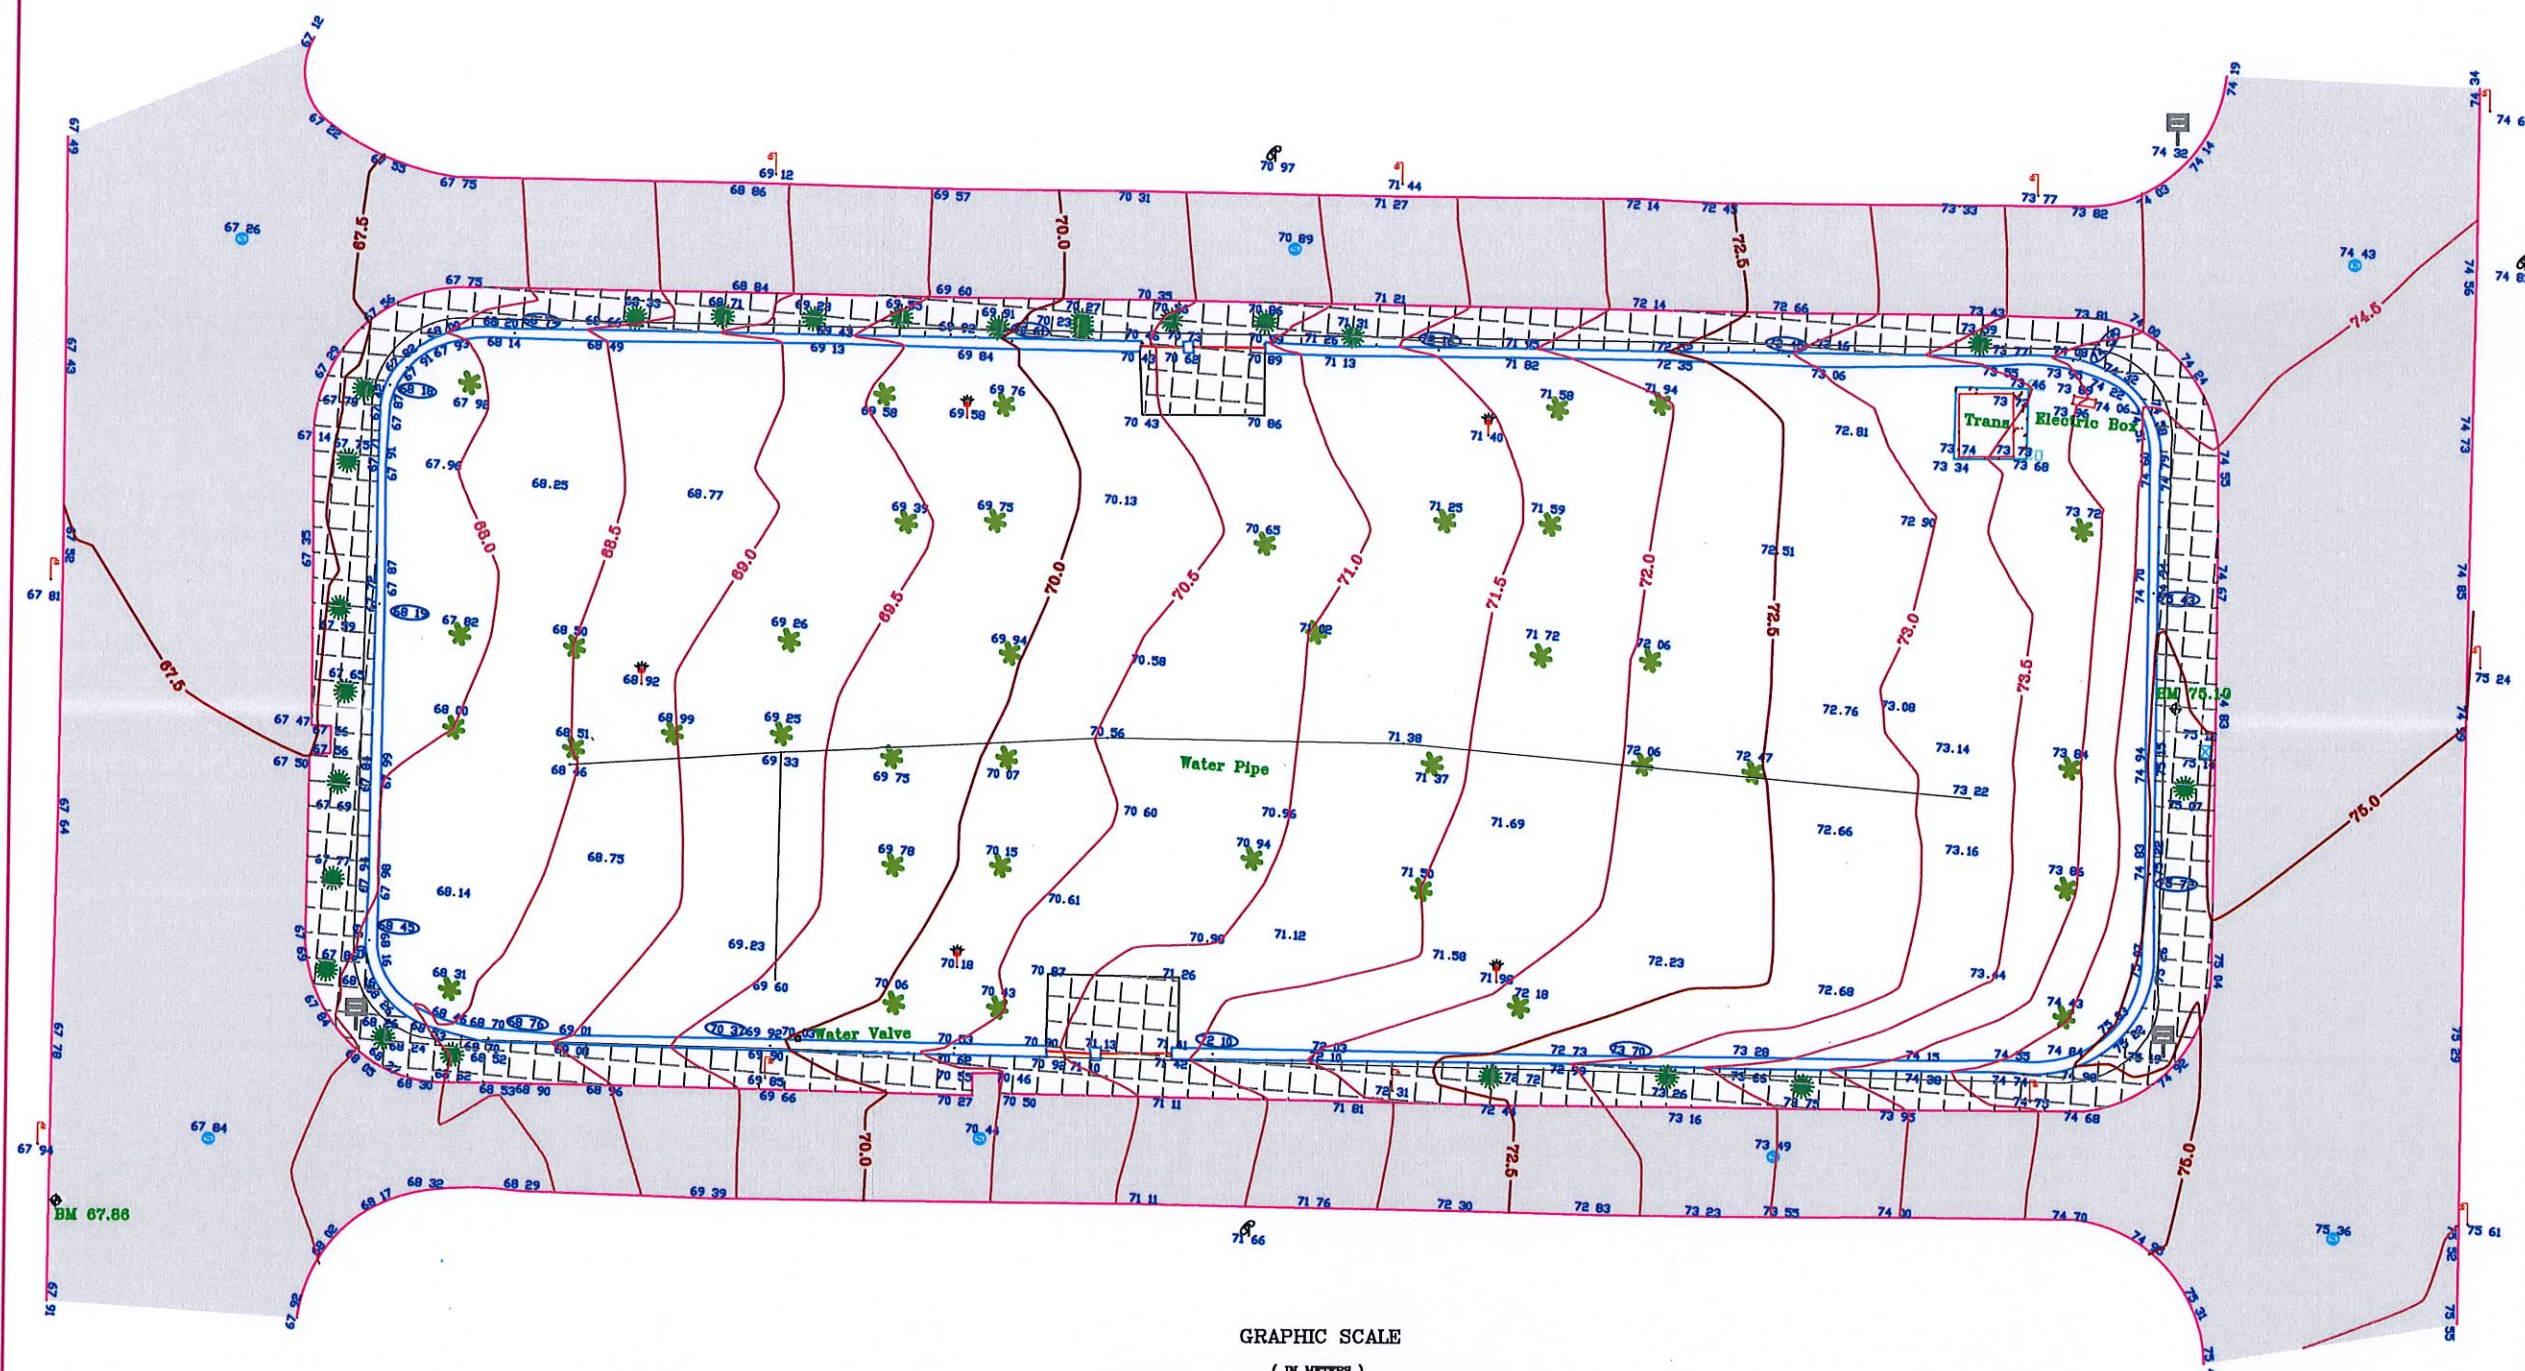

LEGEND

Asphalt Road	
Concrete	
Side Walls	
Arch	
Wall	
Top of Wall	
Railroad	
Light Pole	
Manhole	
Tree	
Telephone Pole	

AQABA GARDENS PROJECT
AQABA - JORDAN

مكتب مهندسين
المستشارات الهندسية

SUBOH CONSULTING ENGINEERS
AMMAN - JORDAN
PHONE 5665789
P.O.BOX 2075
e:mail rsobeh@nol.com.jo
FAX 5661541

PRODUCED BY : geographio studies
SIGNATURE
DESIGNED BY :
SIGNATURE
APPROVAL
CHECKED BY :
SIGNATURE

AQABA GARDENS-PROJECT

PLANS


SHEET	
TOPOGRAPHIC PLAN	
PROJECT NO.	
DATE	THIRD
SCALE	OCTOBER-2008
DRAWING NUMBER	1/200
LAND NO. :	A-001
	140



MIDDLE OF '14m-WIDTH' STREET

MAIN ENTRANCE

existing fence

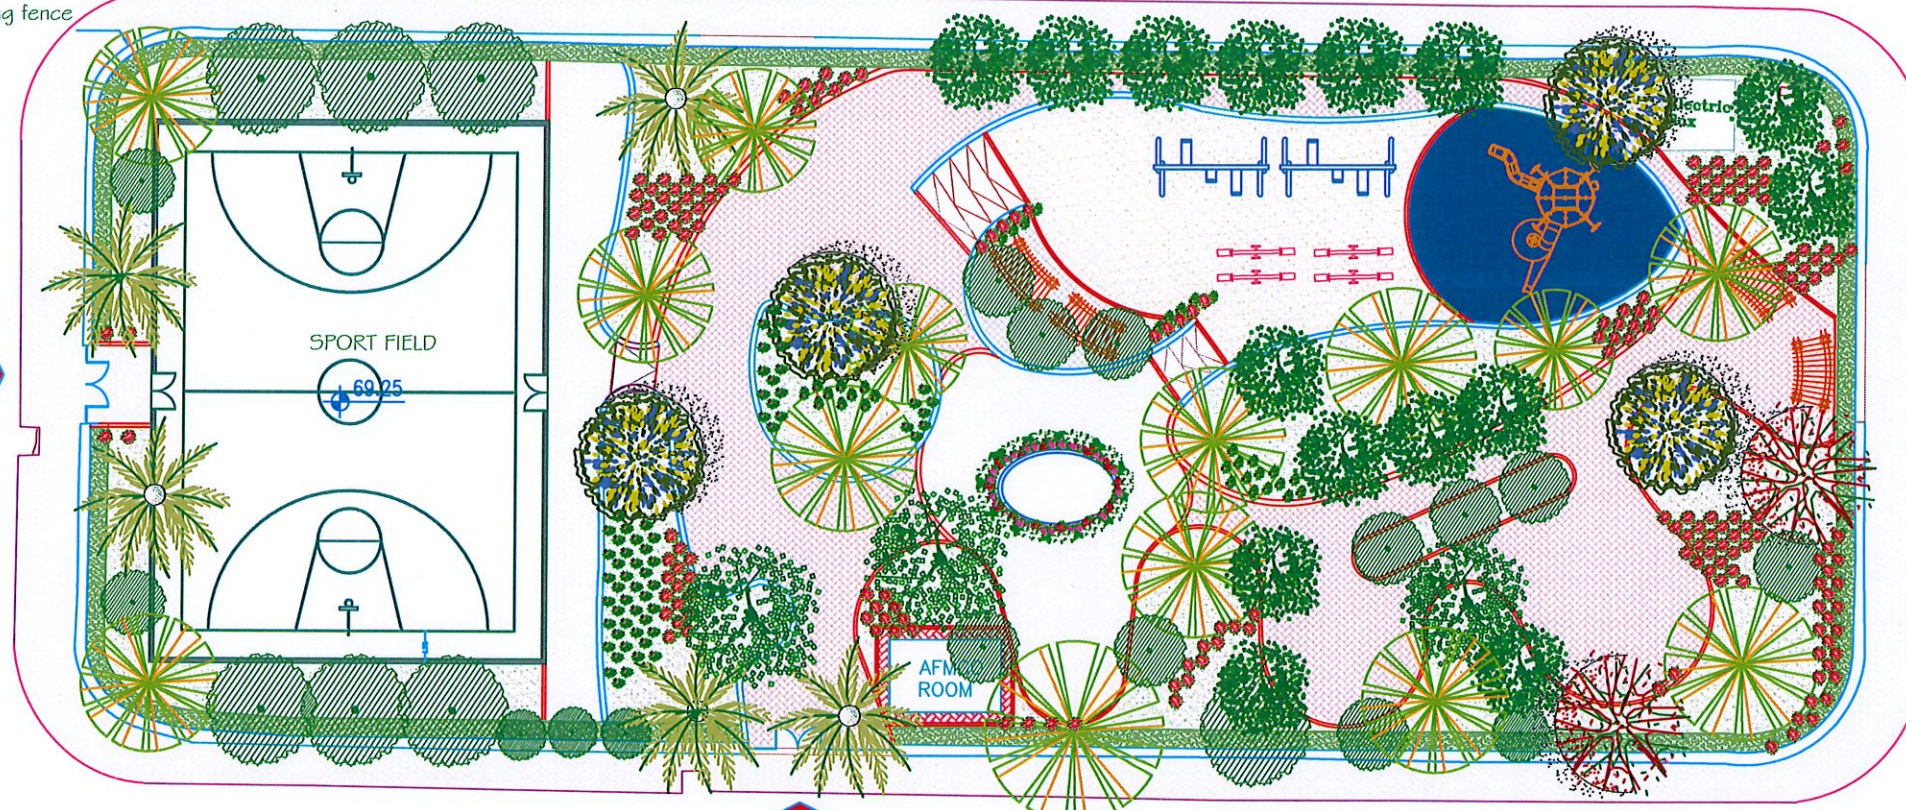

MAIN ENTRANCE

MIDDLE OF '6m-WIDTH' STREET

MIDDLE OF '14m-WIDTH' STREET



AQABA GARDENS PROJECT
AQABA - JORDAN

مكتب مكيح
للمستشارات الهندسية

SUBOH
CONSULTING
ENGINEERS
AMMAN - JORDAN

PHONE 5665789
P.O.BOX 2075
e:mail rsobeh@nol.com.jo
FAX 5661541

PRODUCED BY : ENG. REEMA SALEH
SIGNATURE

DESIGNED BY : ENG. MALEKA
SIGNATURE

APPROVAL
CHECKED BY : ENG. MALEKA
SIGNATURE

AQABA
GARDENS-PROJECT


PLANS

SHEET
MASTER PLAN

PROJECT NO.	
DATE	OCT-2009
SCALE	1/200
DRAWING NUMBER	A-002
LAND NO.	140


existing fence

MAIN ENTRANCE

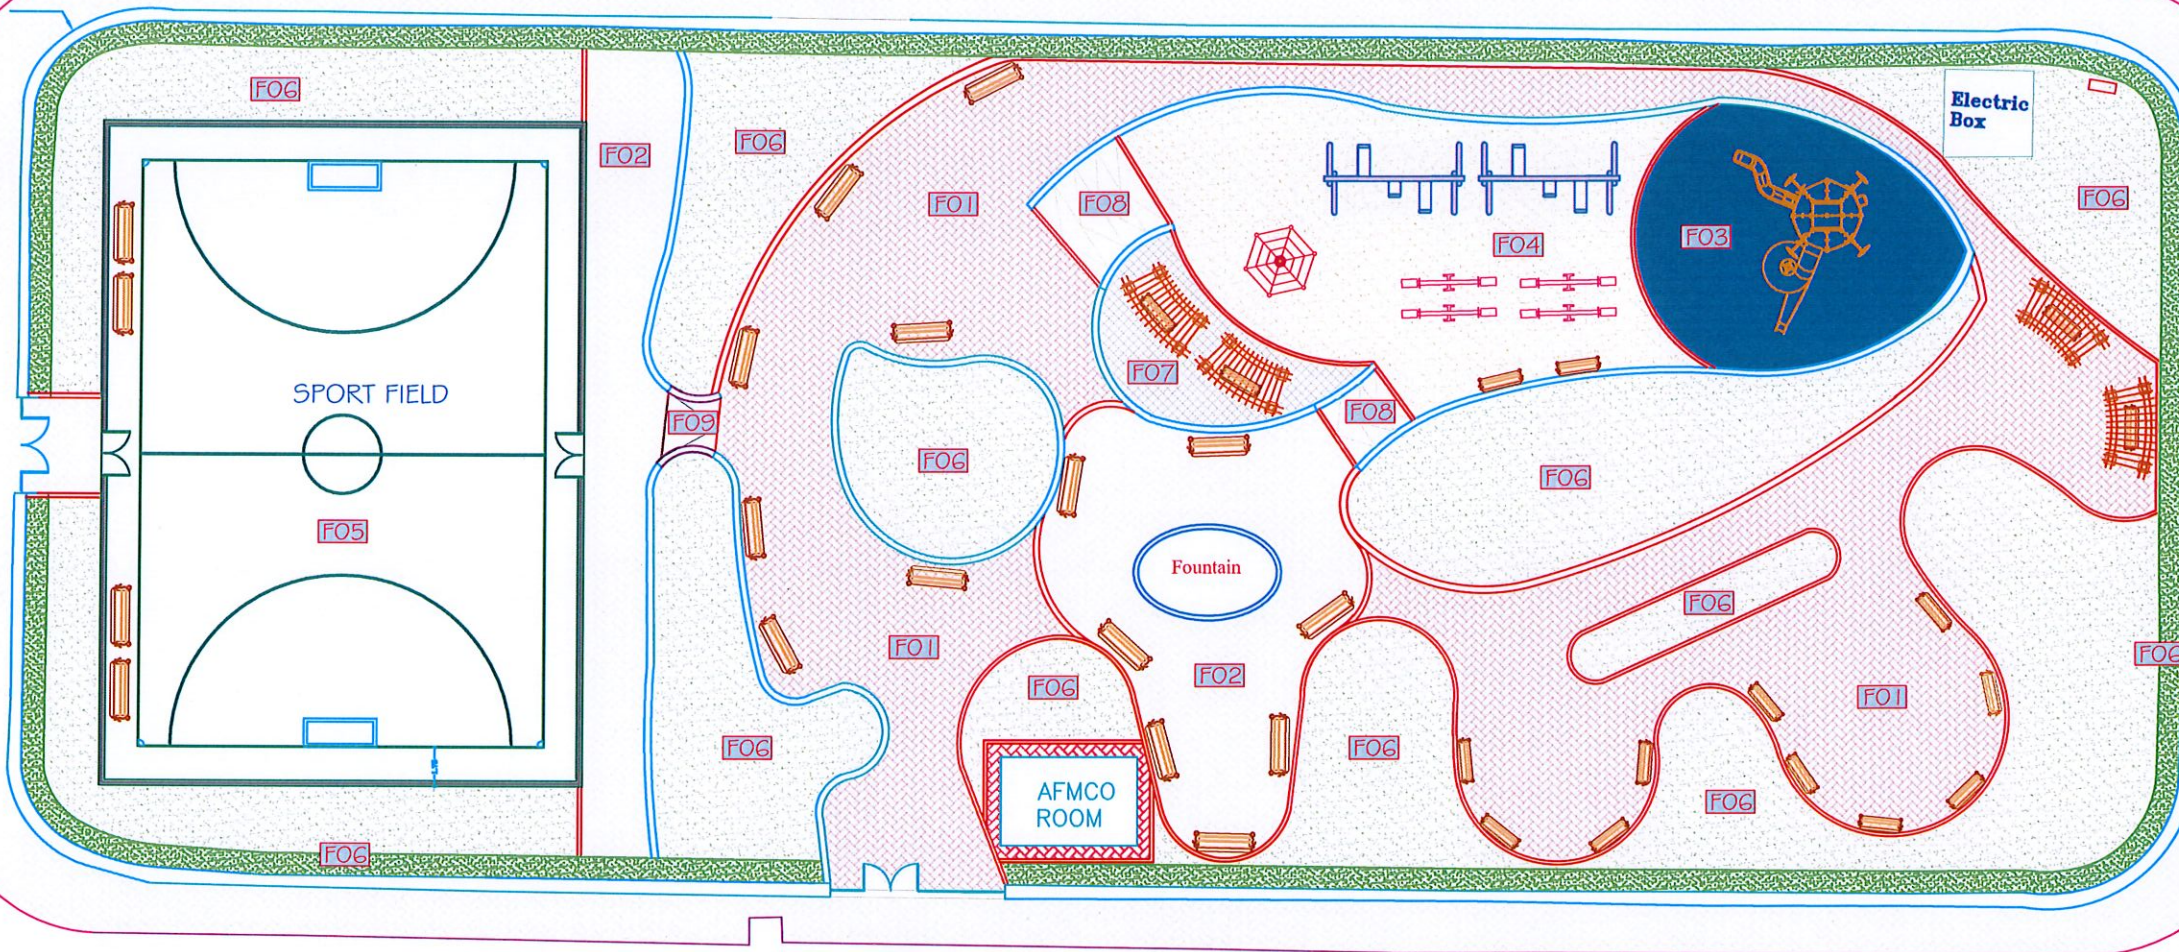

MAIN ENTRANCE

FO1	INTERLOCKING CEMENT TILES (BRICK RED COLOR)
FO2	INTERLOCKING CEMENT TILES (BEIGE COLOR)
FO3	RUBBER FLOOR FOR PLAYGROUND AREA
FO4	SAND
FO5	ASPHALT
FO6	IMPROVED AGRICULTURAL SOIL
FO7	STAMPED CONCRETE
FO8	ROUGH TEXTURE CONCRETE RAMP
FO9	STONE FINISH STAIRS

 

AQABA GARDENS PROJECT
AQABA - JORDAN



SUBOH
CONSULTING
ENGINEERS
AMMAN - JORDAN

PHONE 5665789
P.O.BOX 2075
e:mail rsobeh@nol.com.jo
FAX 5661541

PRODUCED BY : ENG. REEMA SALEH
SIGNATURE

DESIGNED BY : ENG. MALEEKA
SIGNATURE

APPROVAL
CHECKED BY : ENG. MALEEKA
SIGNATURE

AQABA
GARDENS-PROJECT



PLANS

SHEET
LAYOUT, FINISHES &
FURNITURE PLANS

PROJECT NO.	THIRD
DATE	OCT-2009
SCALE	1/200
DRAWING NUMBER	A-003
LAND NO.	140



AFMCO ROOM

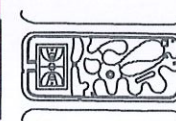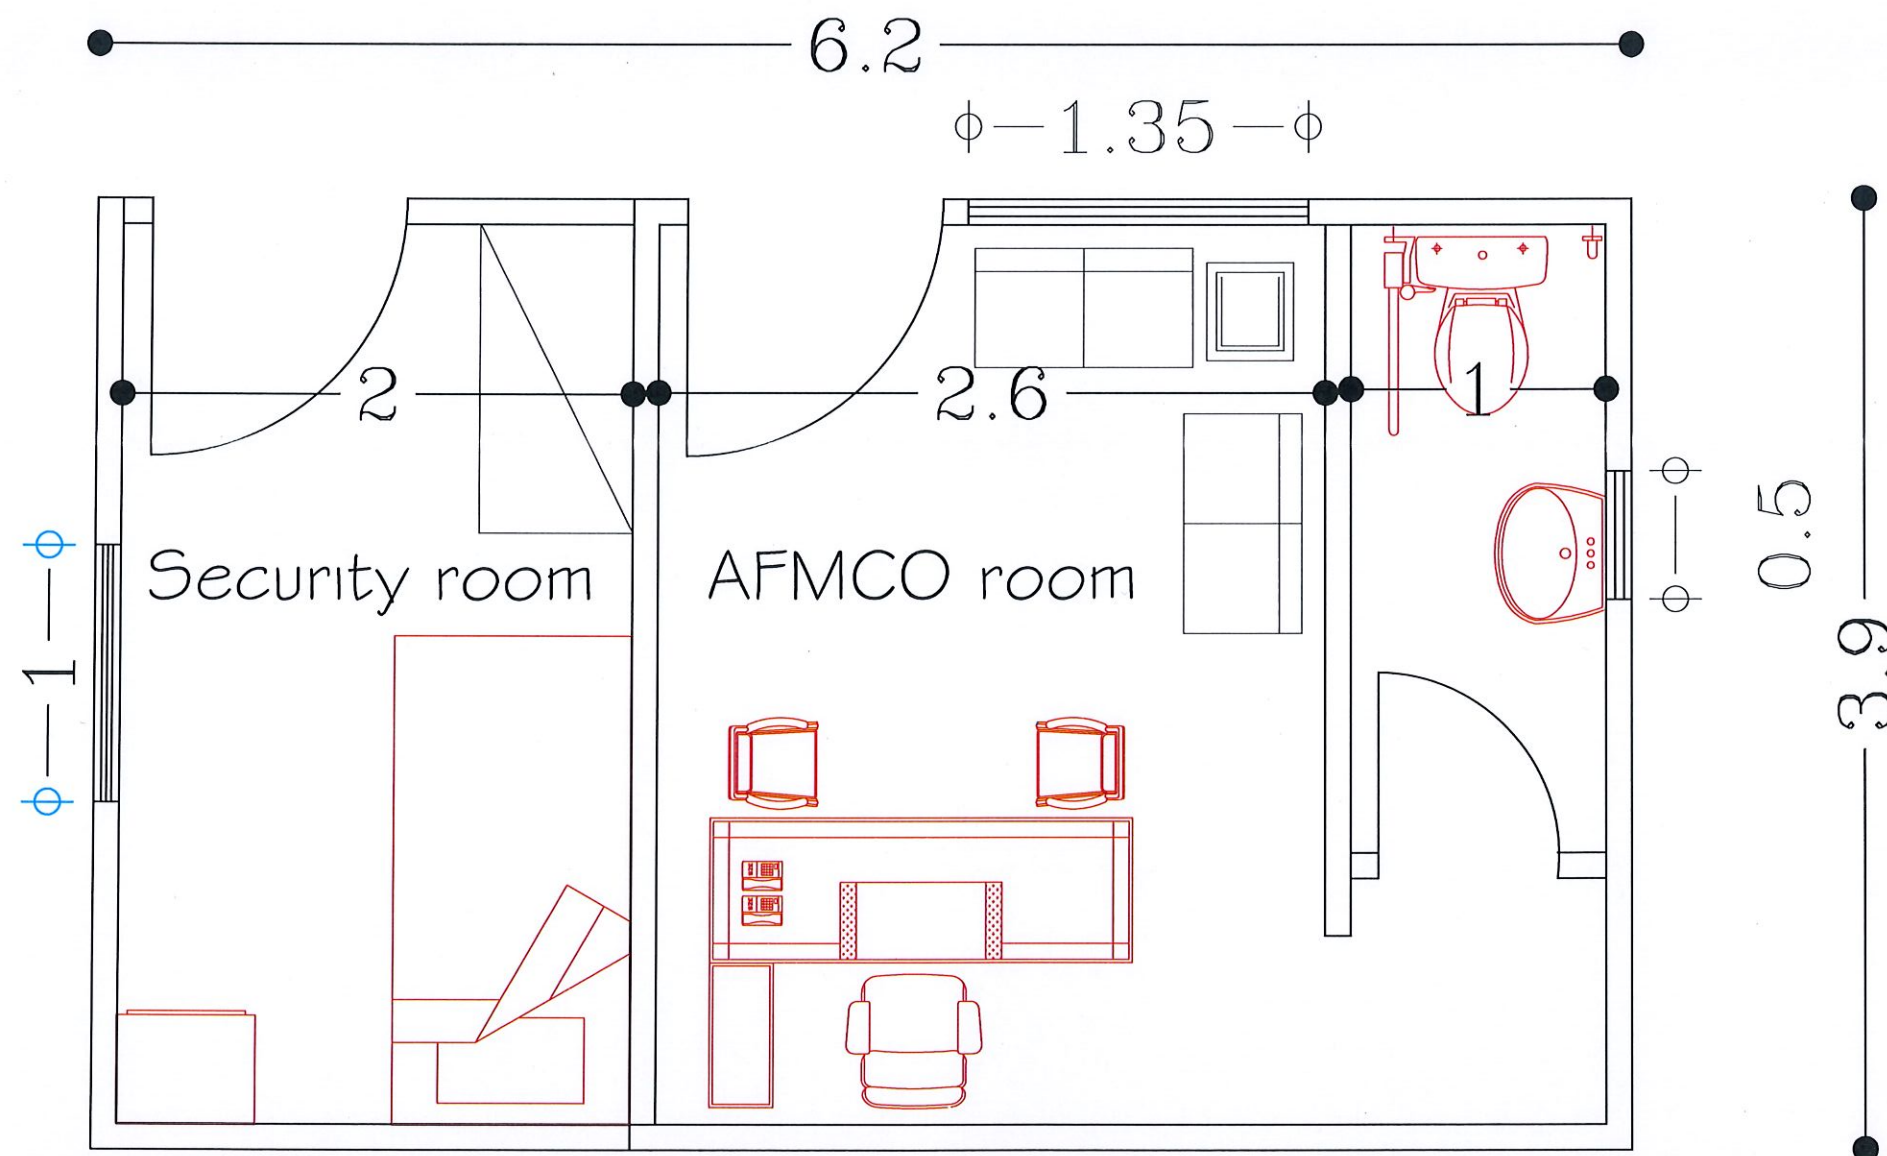

AQABA GARDENS PROJECT
AQABA - JORDAN



SUBOH
CONSULTING
ENGINEERS
AMMAN - JORDAN

PHONE 5665789
P.O.BOX 2075
e:mail rsobeh@nol.com.jo
FAX 5661541

PRODUCED BY : ENG. REEMA SALEH
SIGNATURE

DESIGNED BY : ENG. MALEEK
SIGNATURE

APPROVAL
CHECKED BY : ENG. MALEEK
SIGNATURE

AQABA
GARDENS-PROJECT






PLANS

SHEET
AFMCO BUILDING

PROJECT NO.
PHASE
DATE
SCALE
DRAWING NUMBER

THIRD
OCT-2009
1/200
A-004 LAND NO. : 140

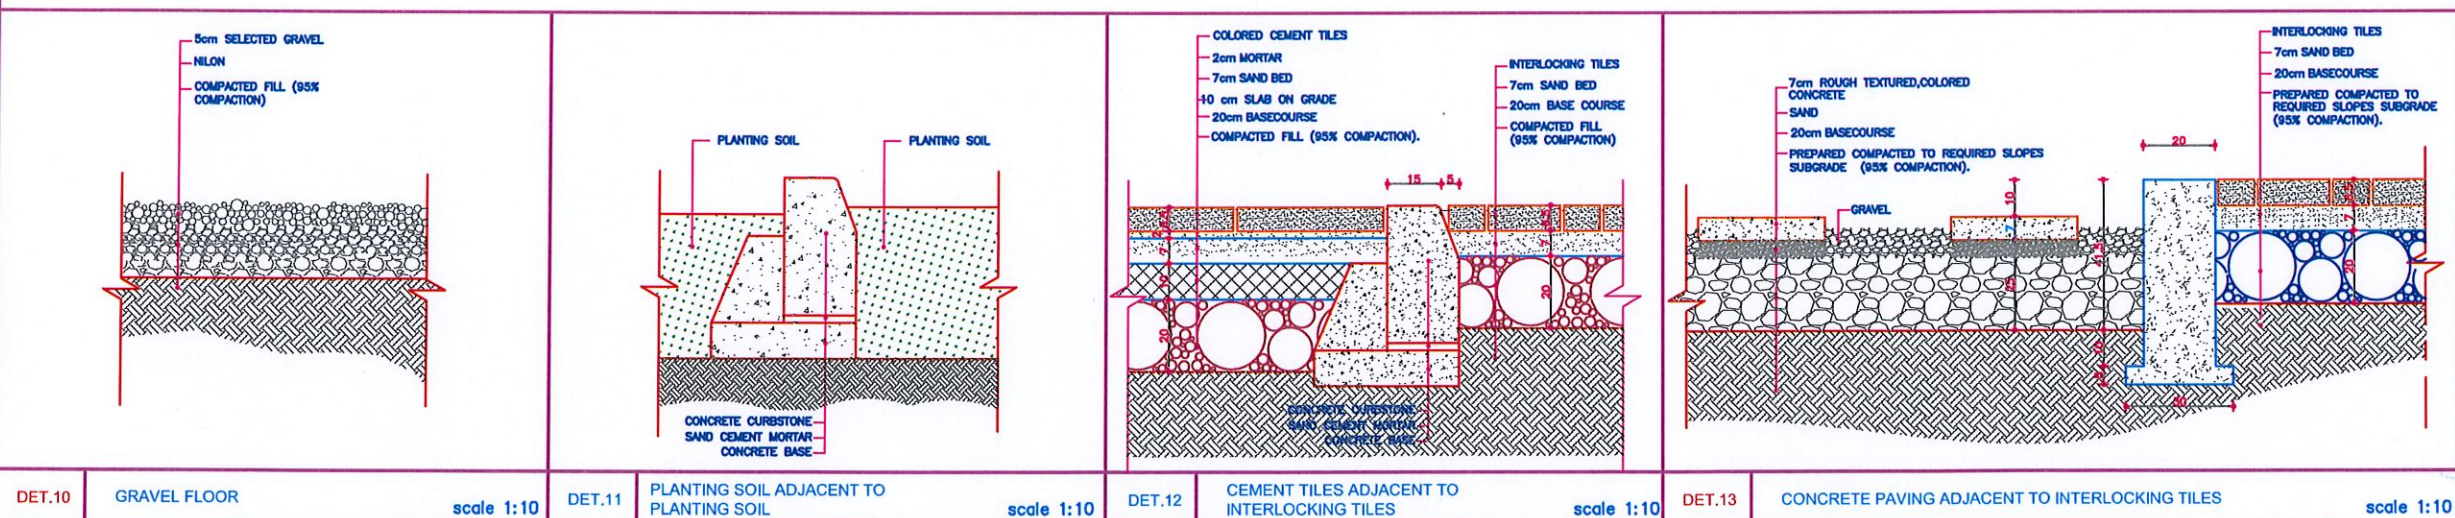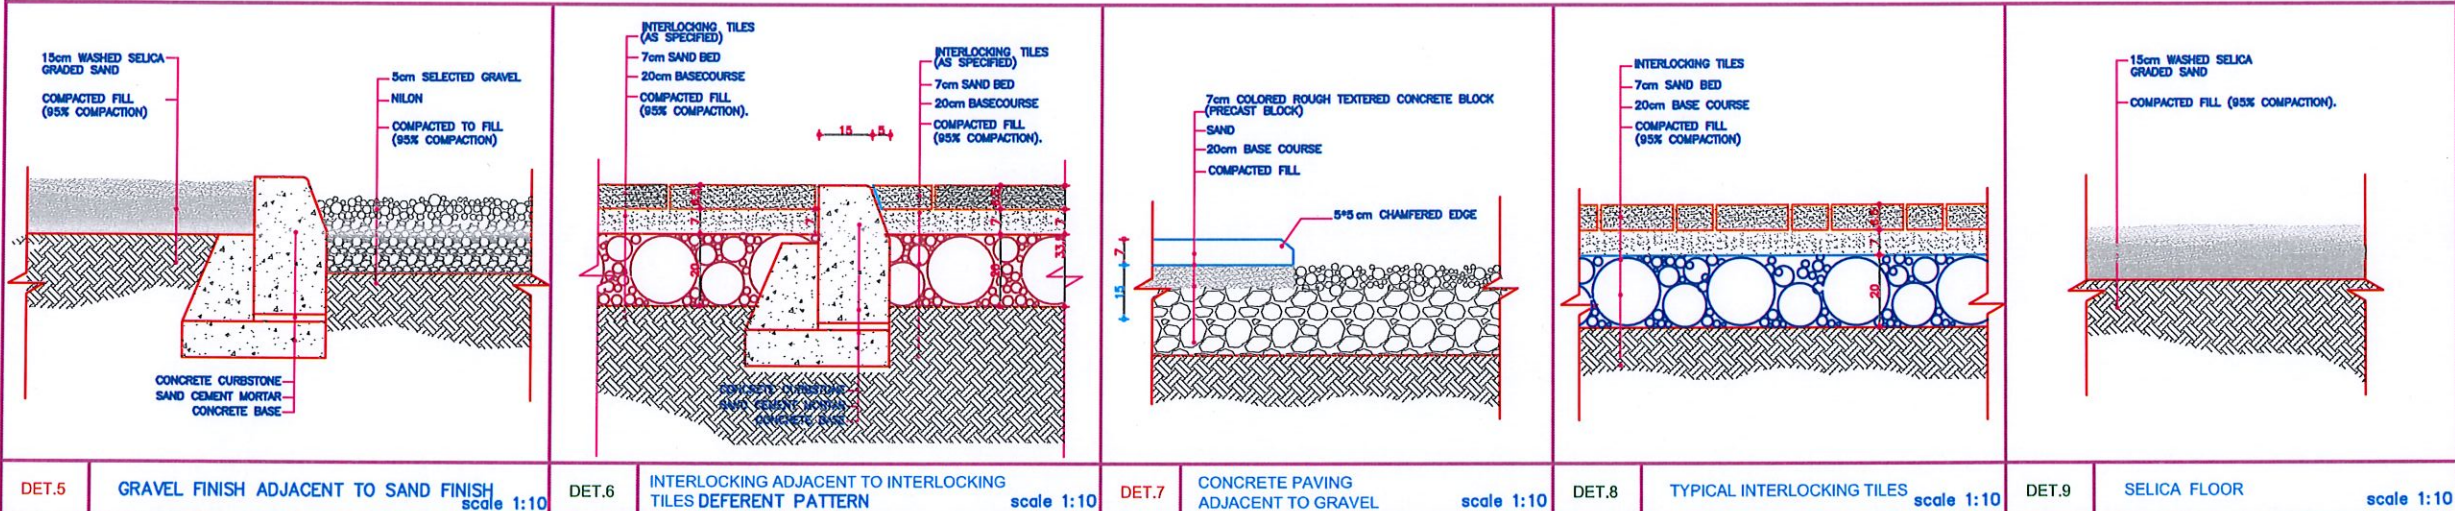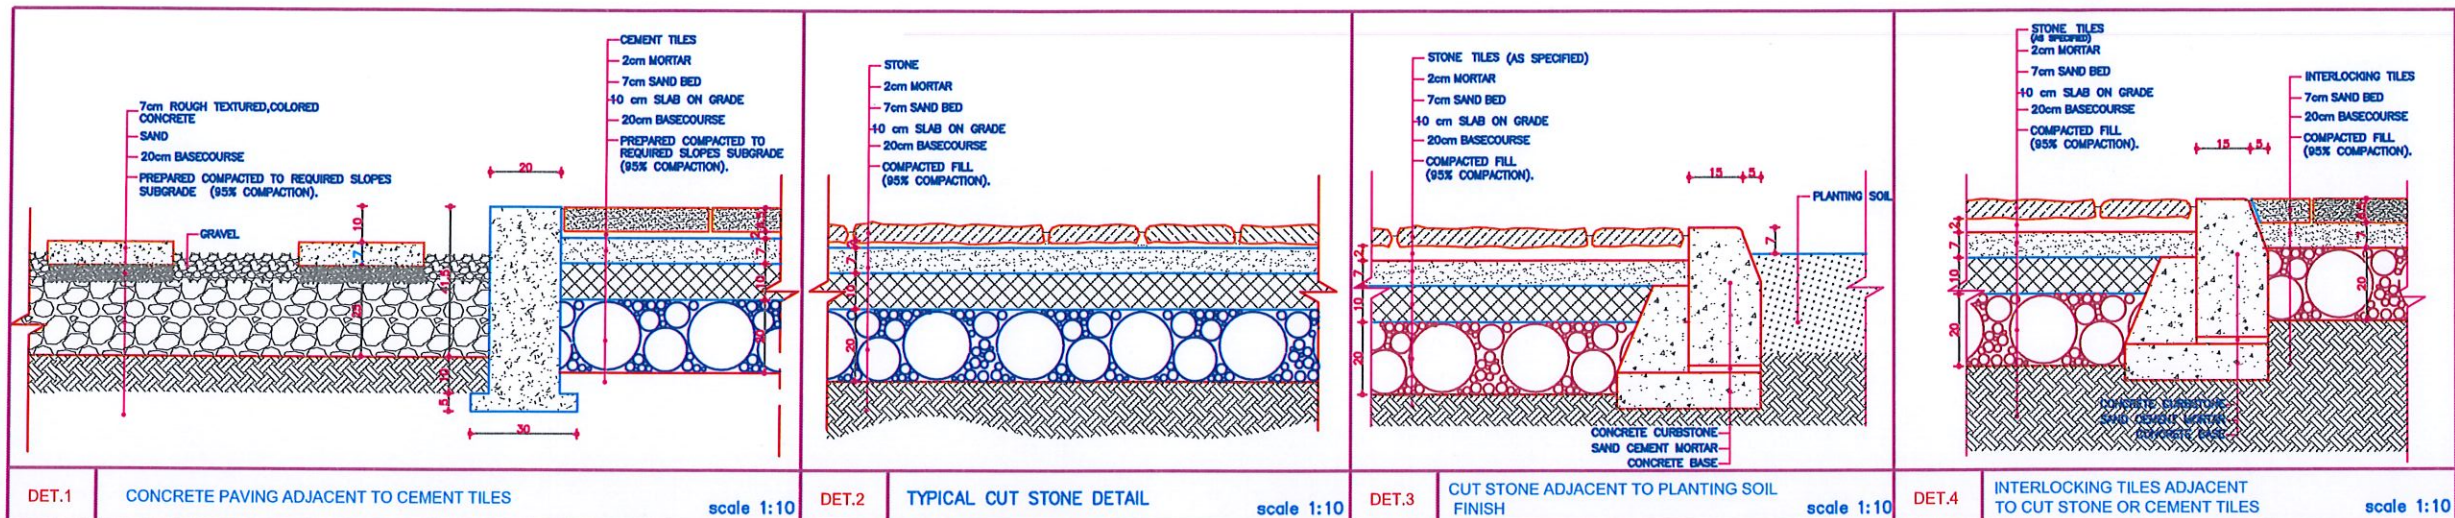

AQABA GARDENS PROJECT
AQABA - JORDAN



SUBOH CONSULTING ENGINEERS
AMMAN - JORDAN

PHONE 5665789
P.O.BOX 2075
e:mail rsobeh@nol.com.jo
FAX 5661541

PRODUCED BY : ENG. REEMA SALEH
SIGNATURE


DESIGNED BY : ENG. MALEKA
SIGNATURE

APPROVAL
CHECKED BY : ENG. MALEKA
SIGNATURE




PROJECT NO.
PHASE
DATE NOVEMBER-2009
SCALE AS SHOWN
DRAWING NUMBER AD-001 LAND NO. : 140


78

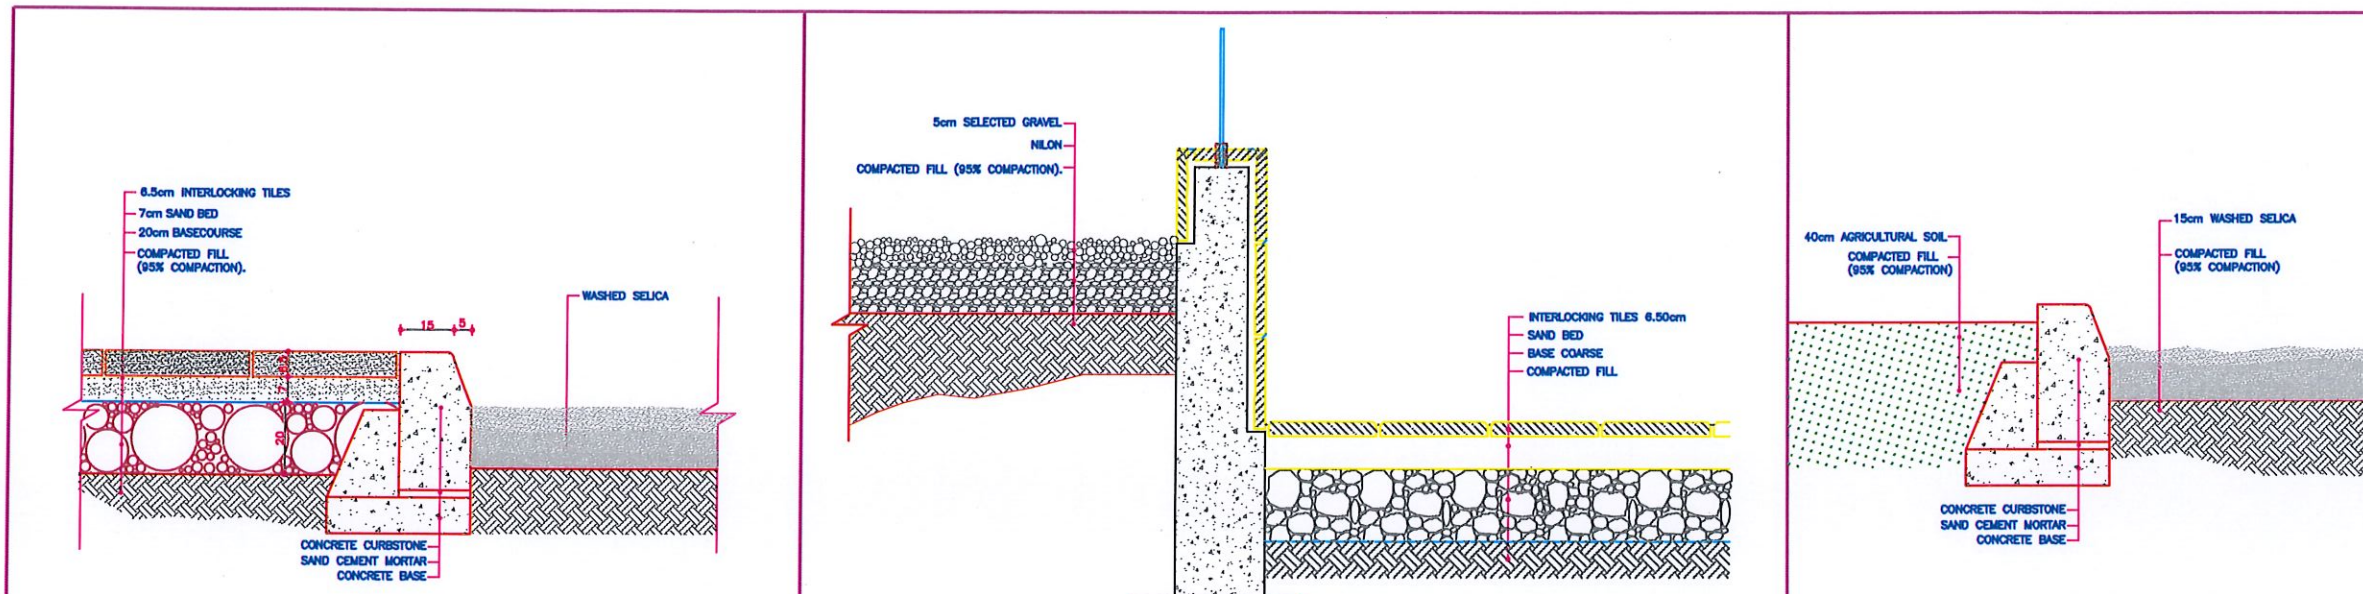

DET.1 INTERLOCKING ADJACENT TO SAND FINISH OR PLANTING SOIL scale 1:10 DET.2 INTERLOCKING ADJACENT TO GRAVEL scale 1:10 DET.3 SAND FINISH ADJACENT TO PLANTING SOIL scale 1:10

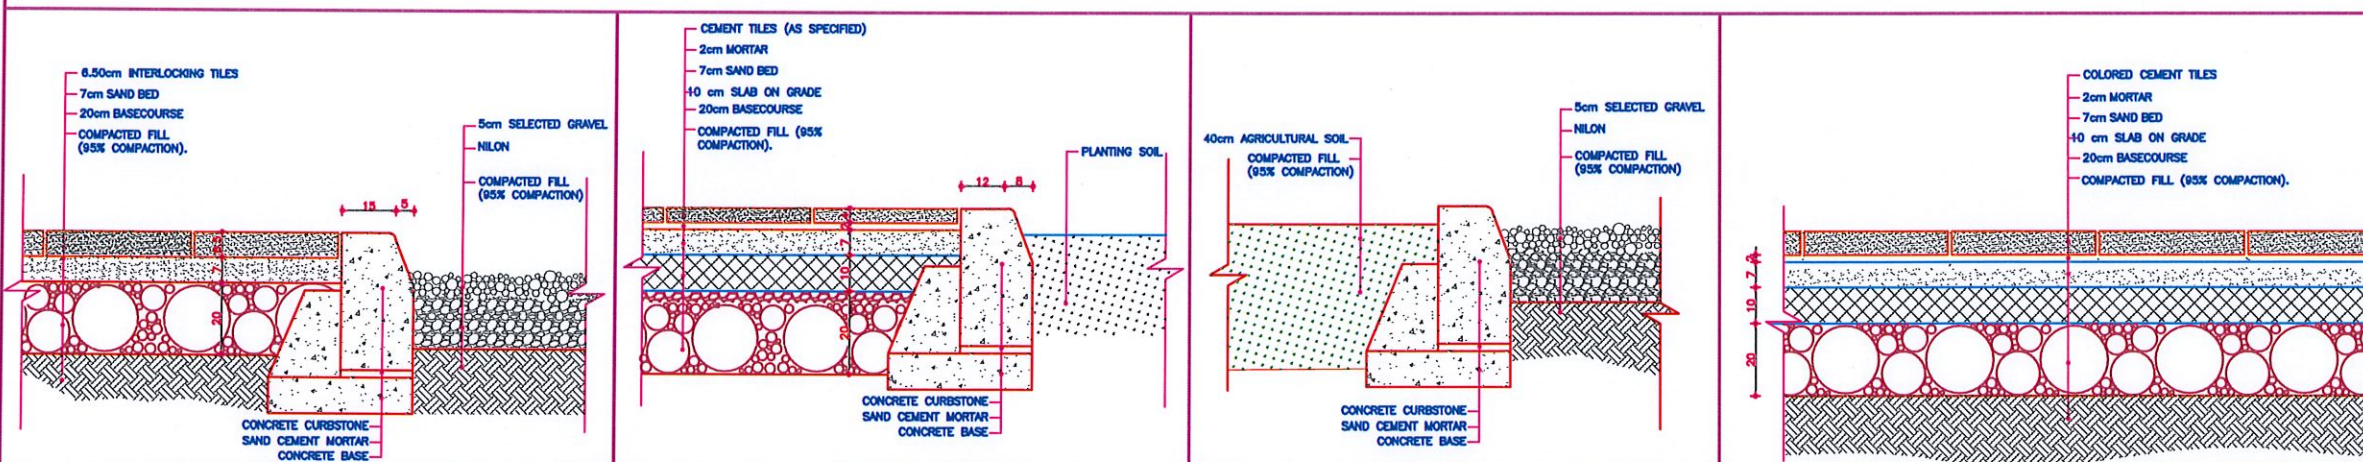





DET.4 INTERLOCKING ADJACENT TO GRAVEL FINISH scale 1:10 DET.5 CEMENT ADJACENT TO PLANTING SOIL OR SAND scale 1:10 DET.6 PLANTING SOIL ADJACENT TO GRAVEL FINISH scale 1:10 DET.7 TYPICAL CEMENT TILE DETAIL scale 1:10

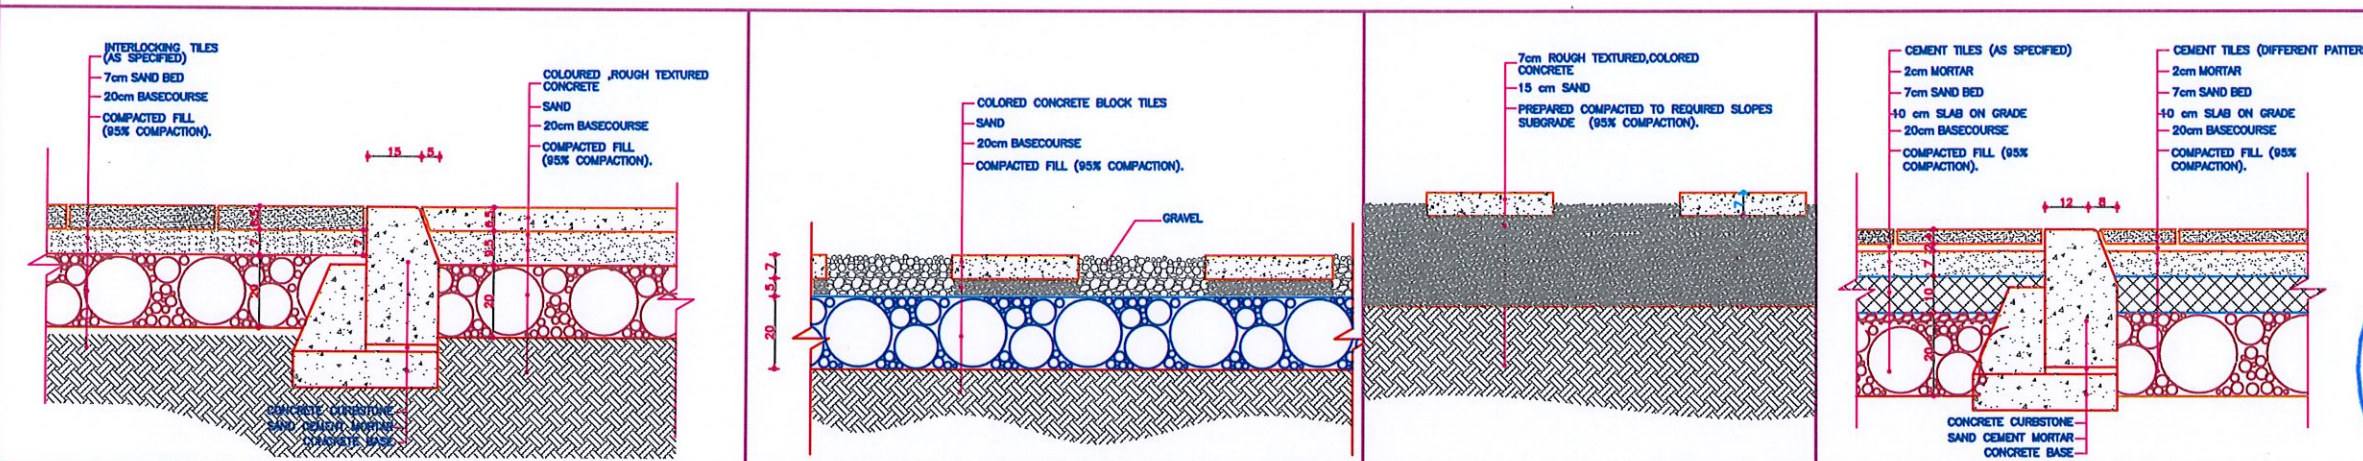

DET.8 INTERLOCKING ADJACENT TO CONCRETE PAVING scale 1:10 DET.9 CONCRETE PAVING ADJACENT TO GRAVEL FINISH scale 1:10 DET.10 CONCRETE PAVING ON SAND scale 1:10 DET.11 CEMENT TILES ADJACENT TO CEMENT TILES DIFFERENT PATTERN scale 1:10



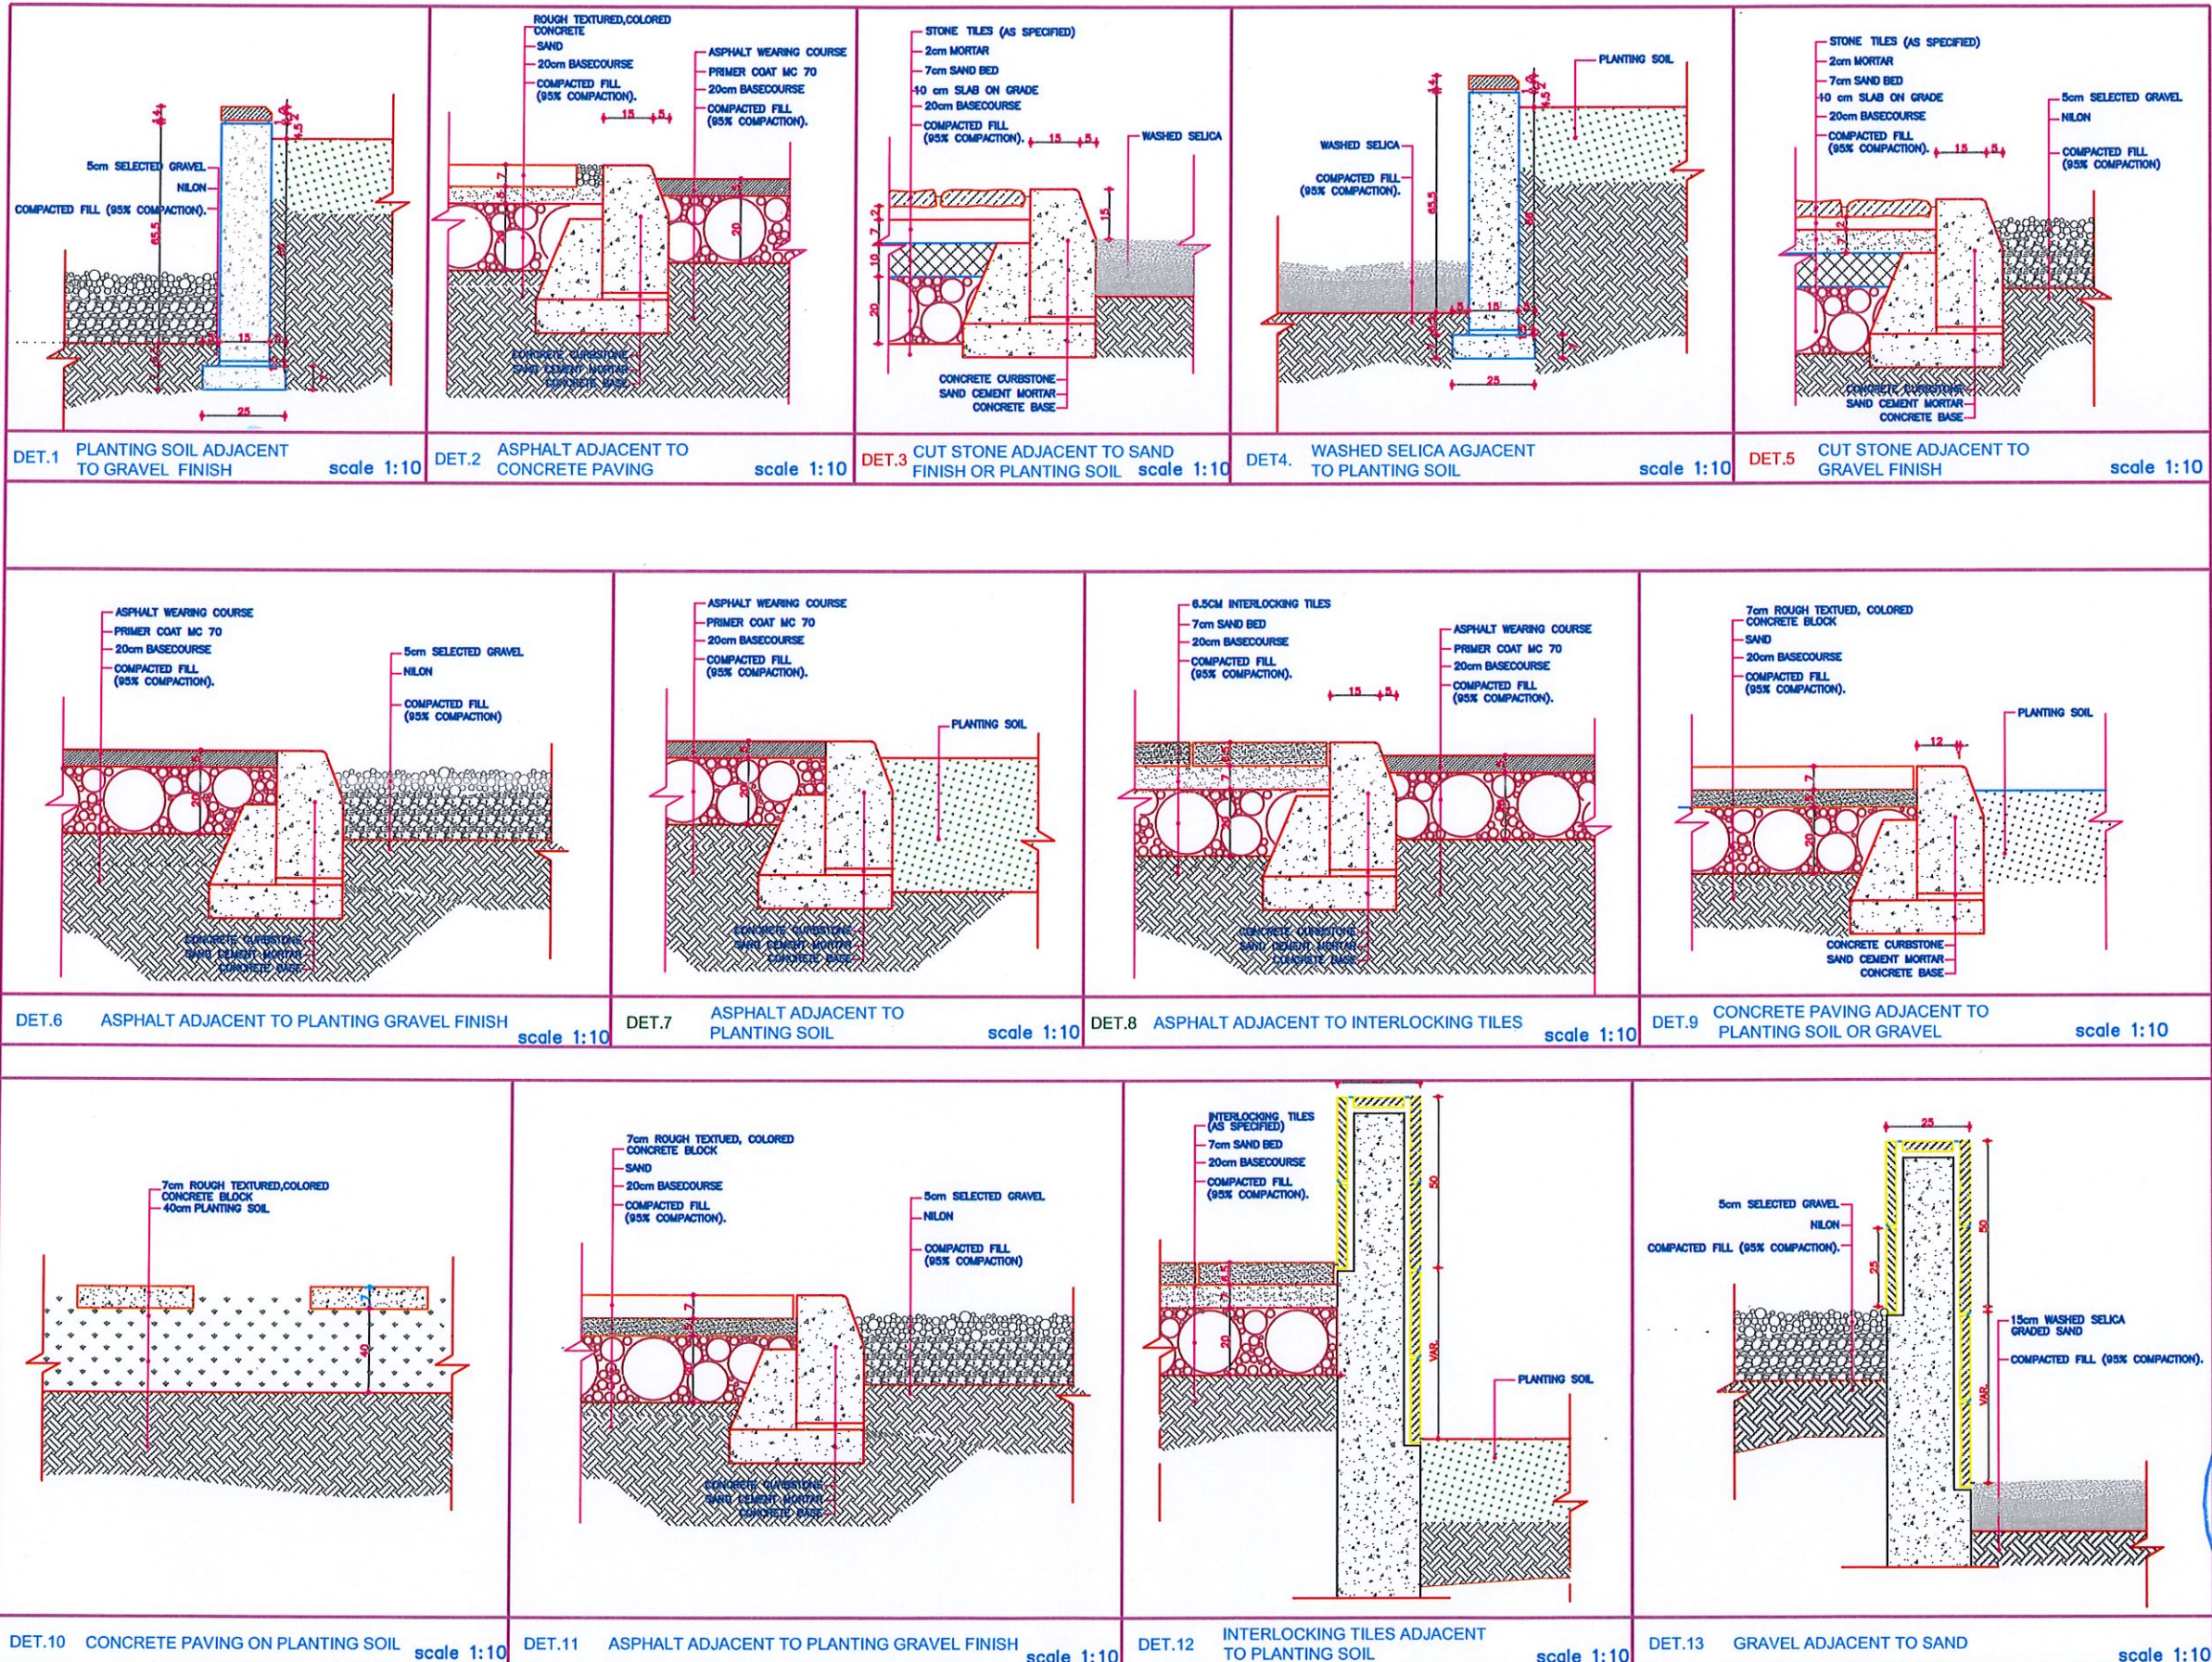

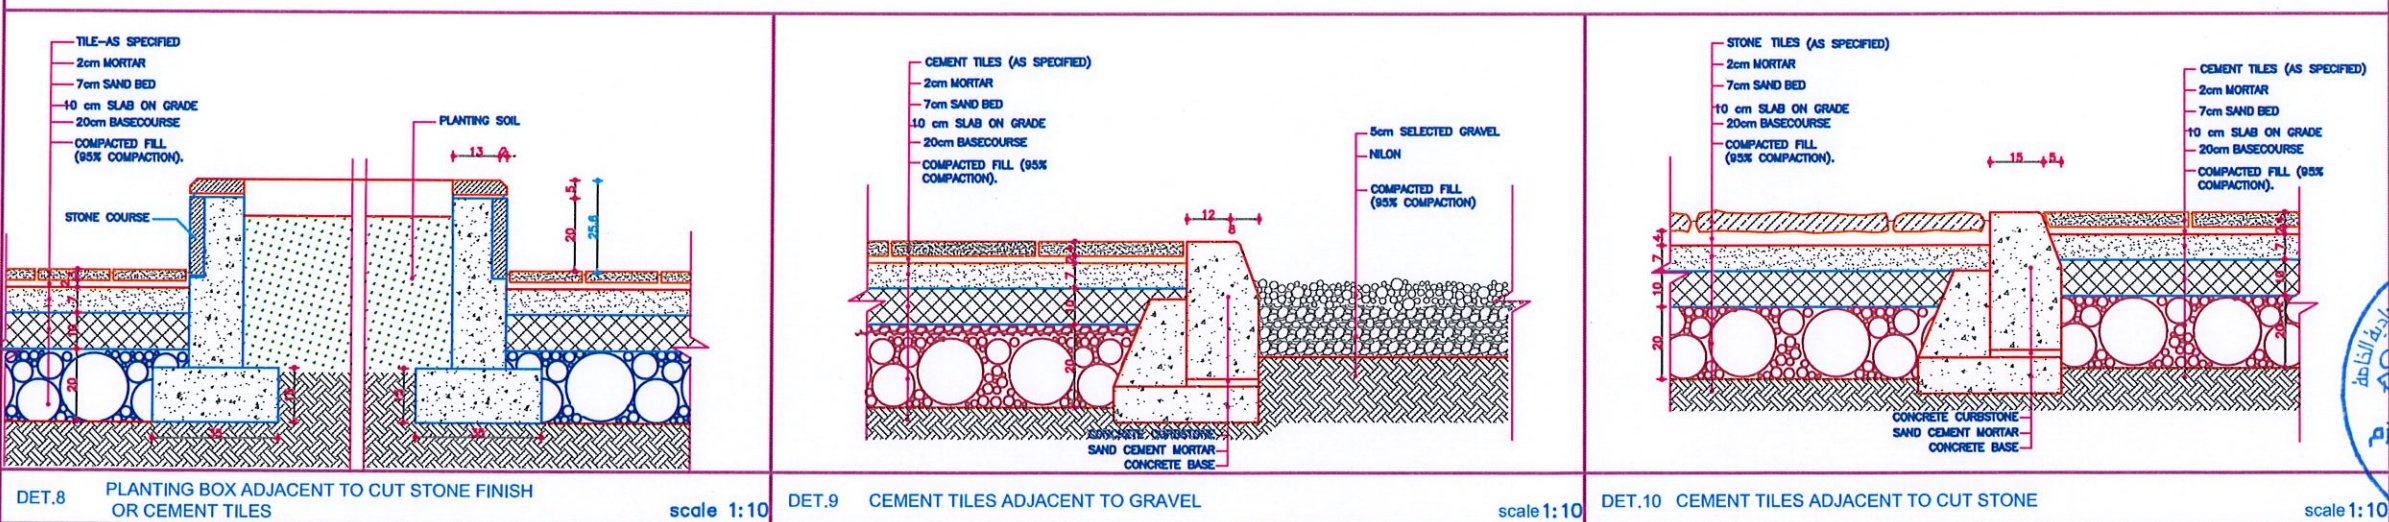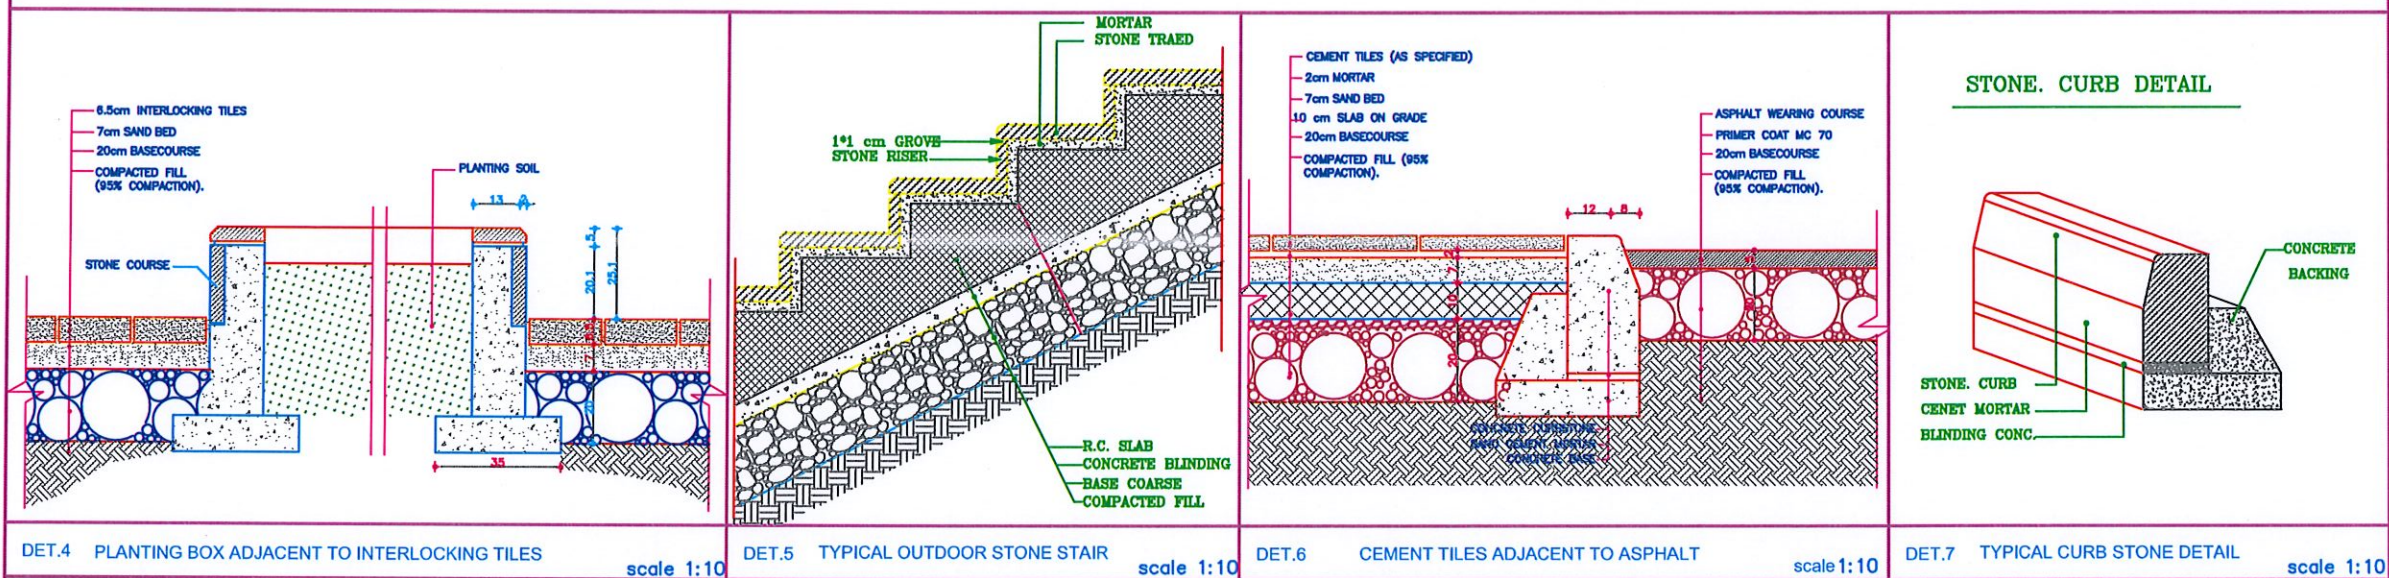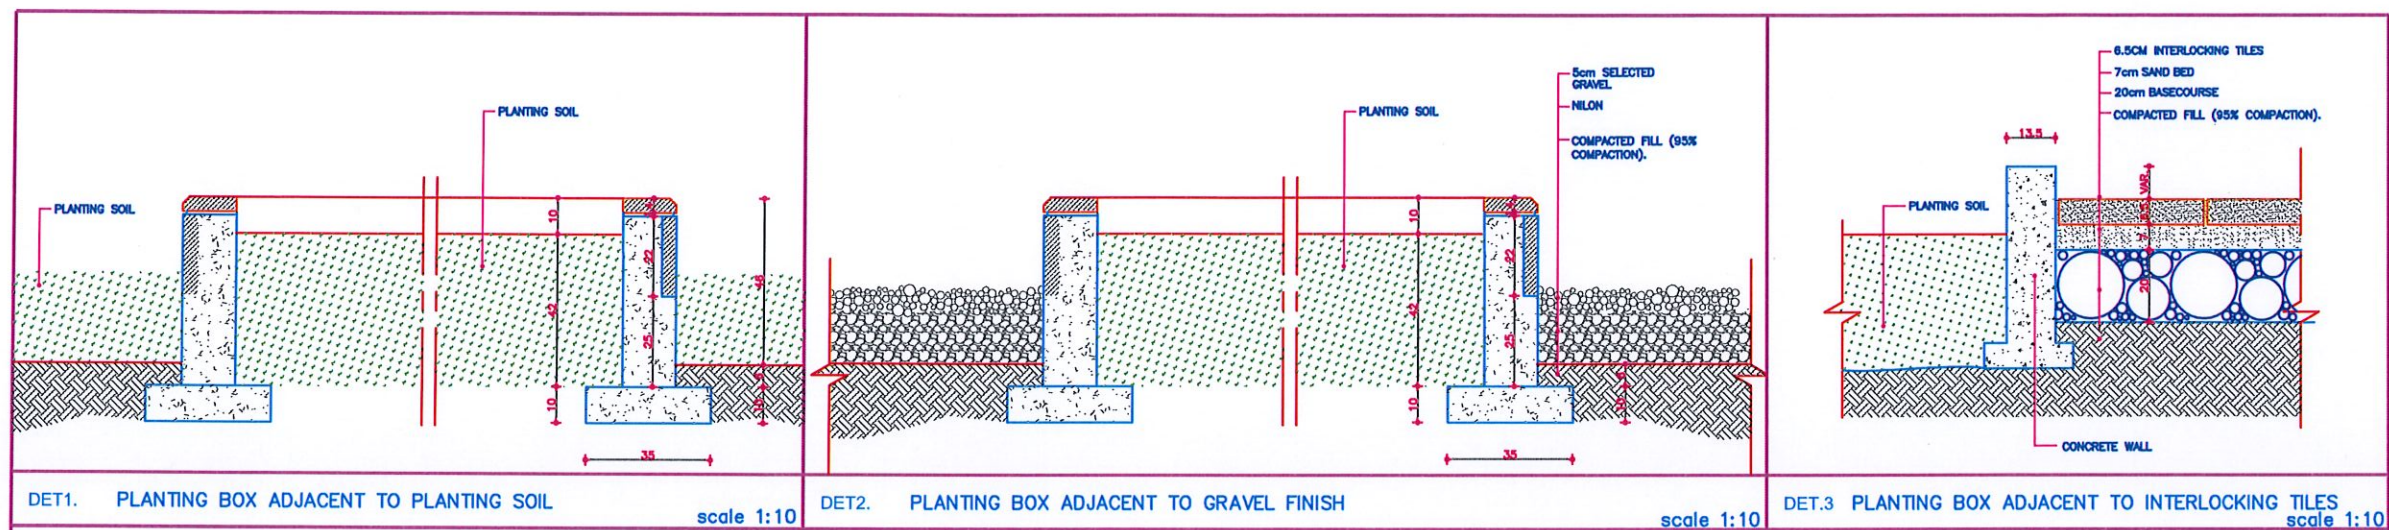

AQABA GARDENS PROJECT
AQABA - JORDAN



SUBOH
CONSULTING
ENGINEERS
AMMAN - JORDAN

PHONE 5665789
P.O.BOX 2075
e:mail rasbeh@nol.com.jo
FAX 5661541

PRODUCED BY : ENG. REZMA SALEM
SIGNATURE

DESIGNED BY : ENG. MALEKA
SIGNATURE

APPROVAL
CHECKED BY : ENG. MALEKA
SIGNATURE

AQABA GARDENS
PROJECT

GENERAL DETAILS

SHEET

DETAILS




PHASE

DATE NOVEMBER-2008

SCALE VARIES

DRAWING NUMBER AD-004

LAND NO. 140

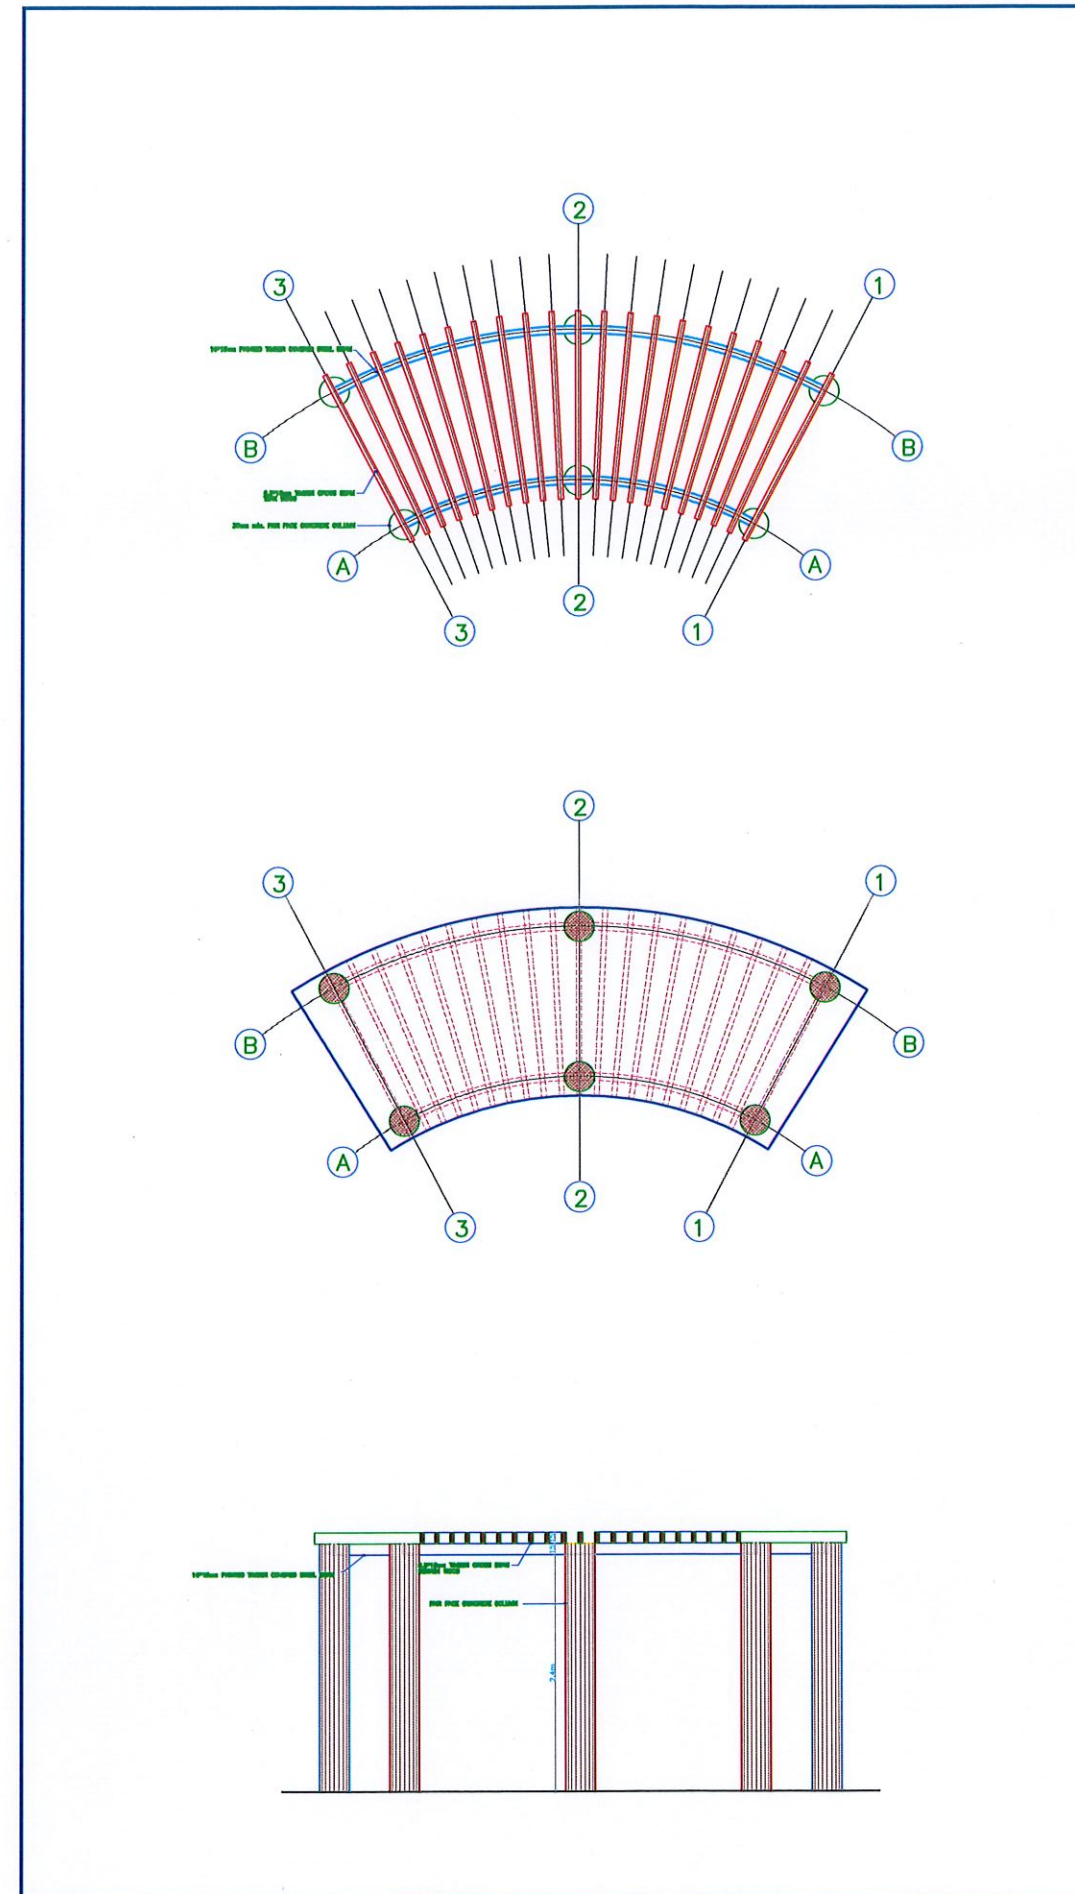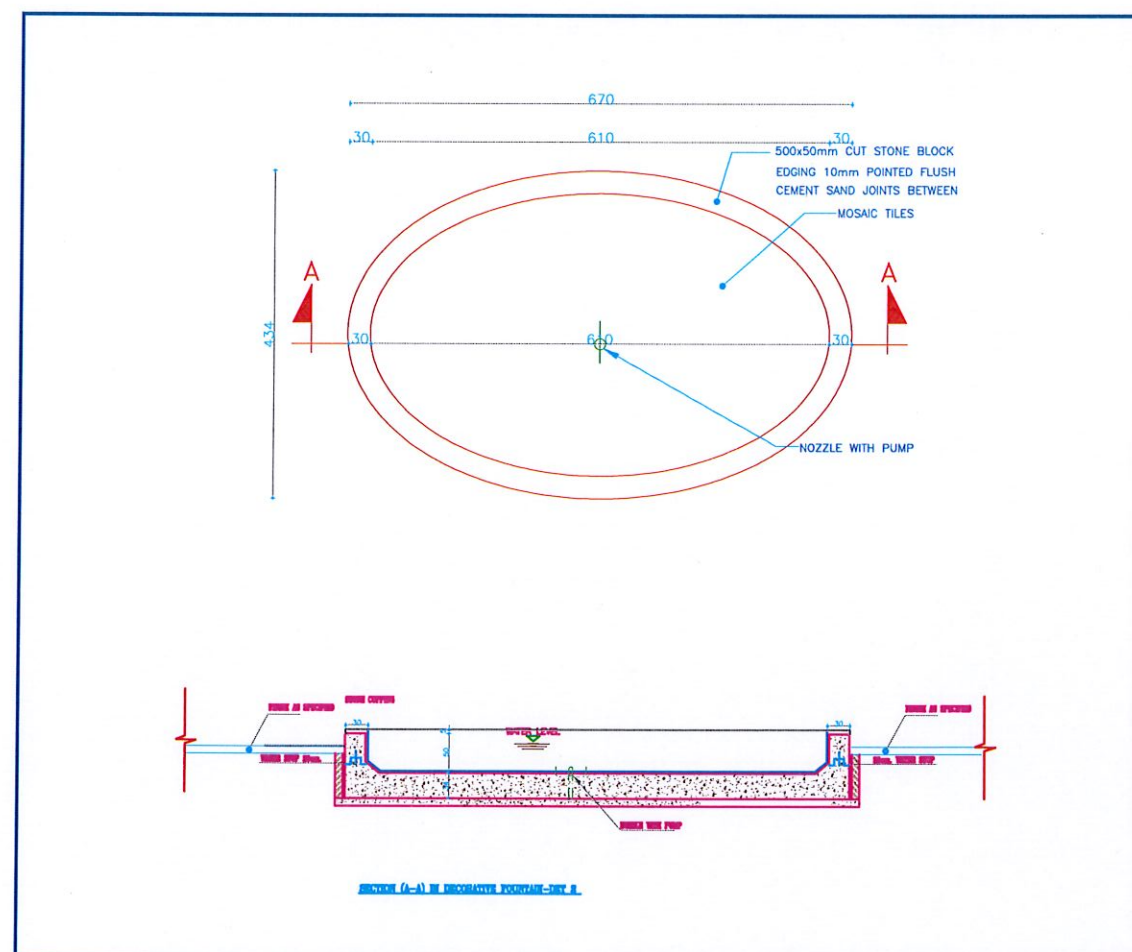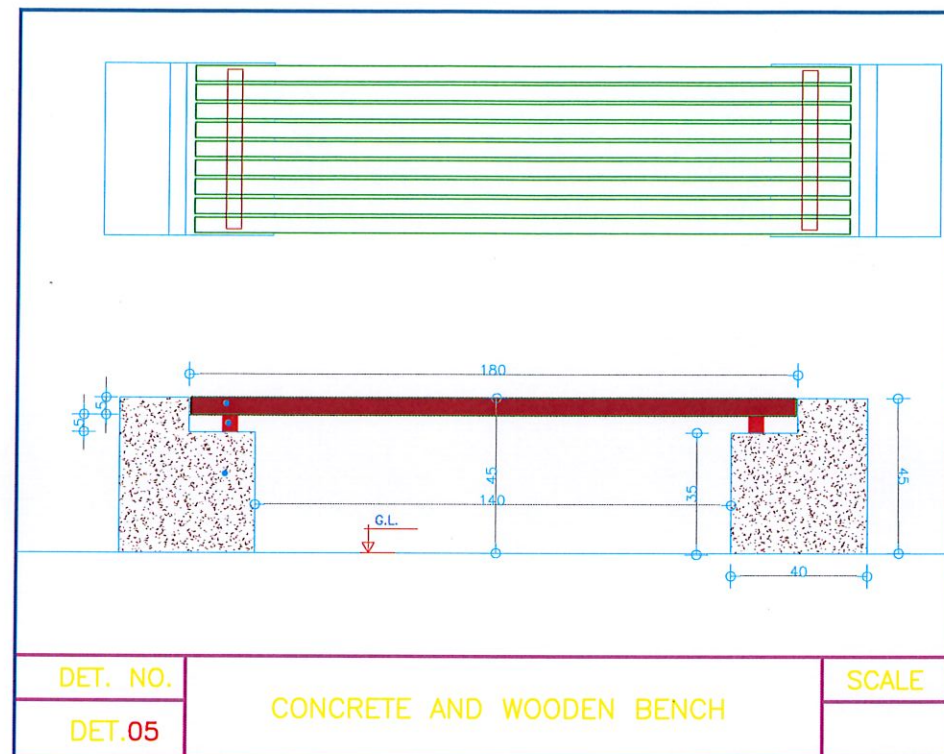

AQABA GARDENS PROJECT
AQABA - JORDAN



SUBOH
CONSULTING
ENGINEERS
AMMAN - JORDAN

PHONE 5665789
P.O.BOX 2075
e:mail rsobeh@nol.com.jo
FAX 5661541

PRODUCED BY : ENG. MALEKA
SIGNATURE

DESIGNED BY : ENG. MALEKA
SIGNATURE

APPROVAL
CHECKED BY : ENG. MALEKA
SIGNATURE

AQABA
GARDENS-PROJECT

GENERAL DETAILS

SHEET

FOUNTAINS & FURNITURE

قسم العتبات

PROJECT NO.

DATE NOVEMBER-2005


SCALE VARIES

DRAWING NUMBER AD-005



LAND NO. : 140

NOTES


1. ALL LINES ARE 80mm WIDE
2. SPORTS EQUIPMENT AS SPECIFIED
3. COLORCOAT LAYERS TO EXTEND BEYOND SURFACE MARKINGS

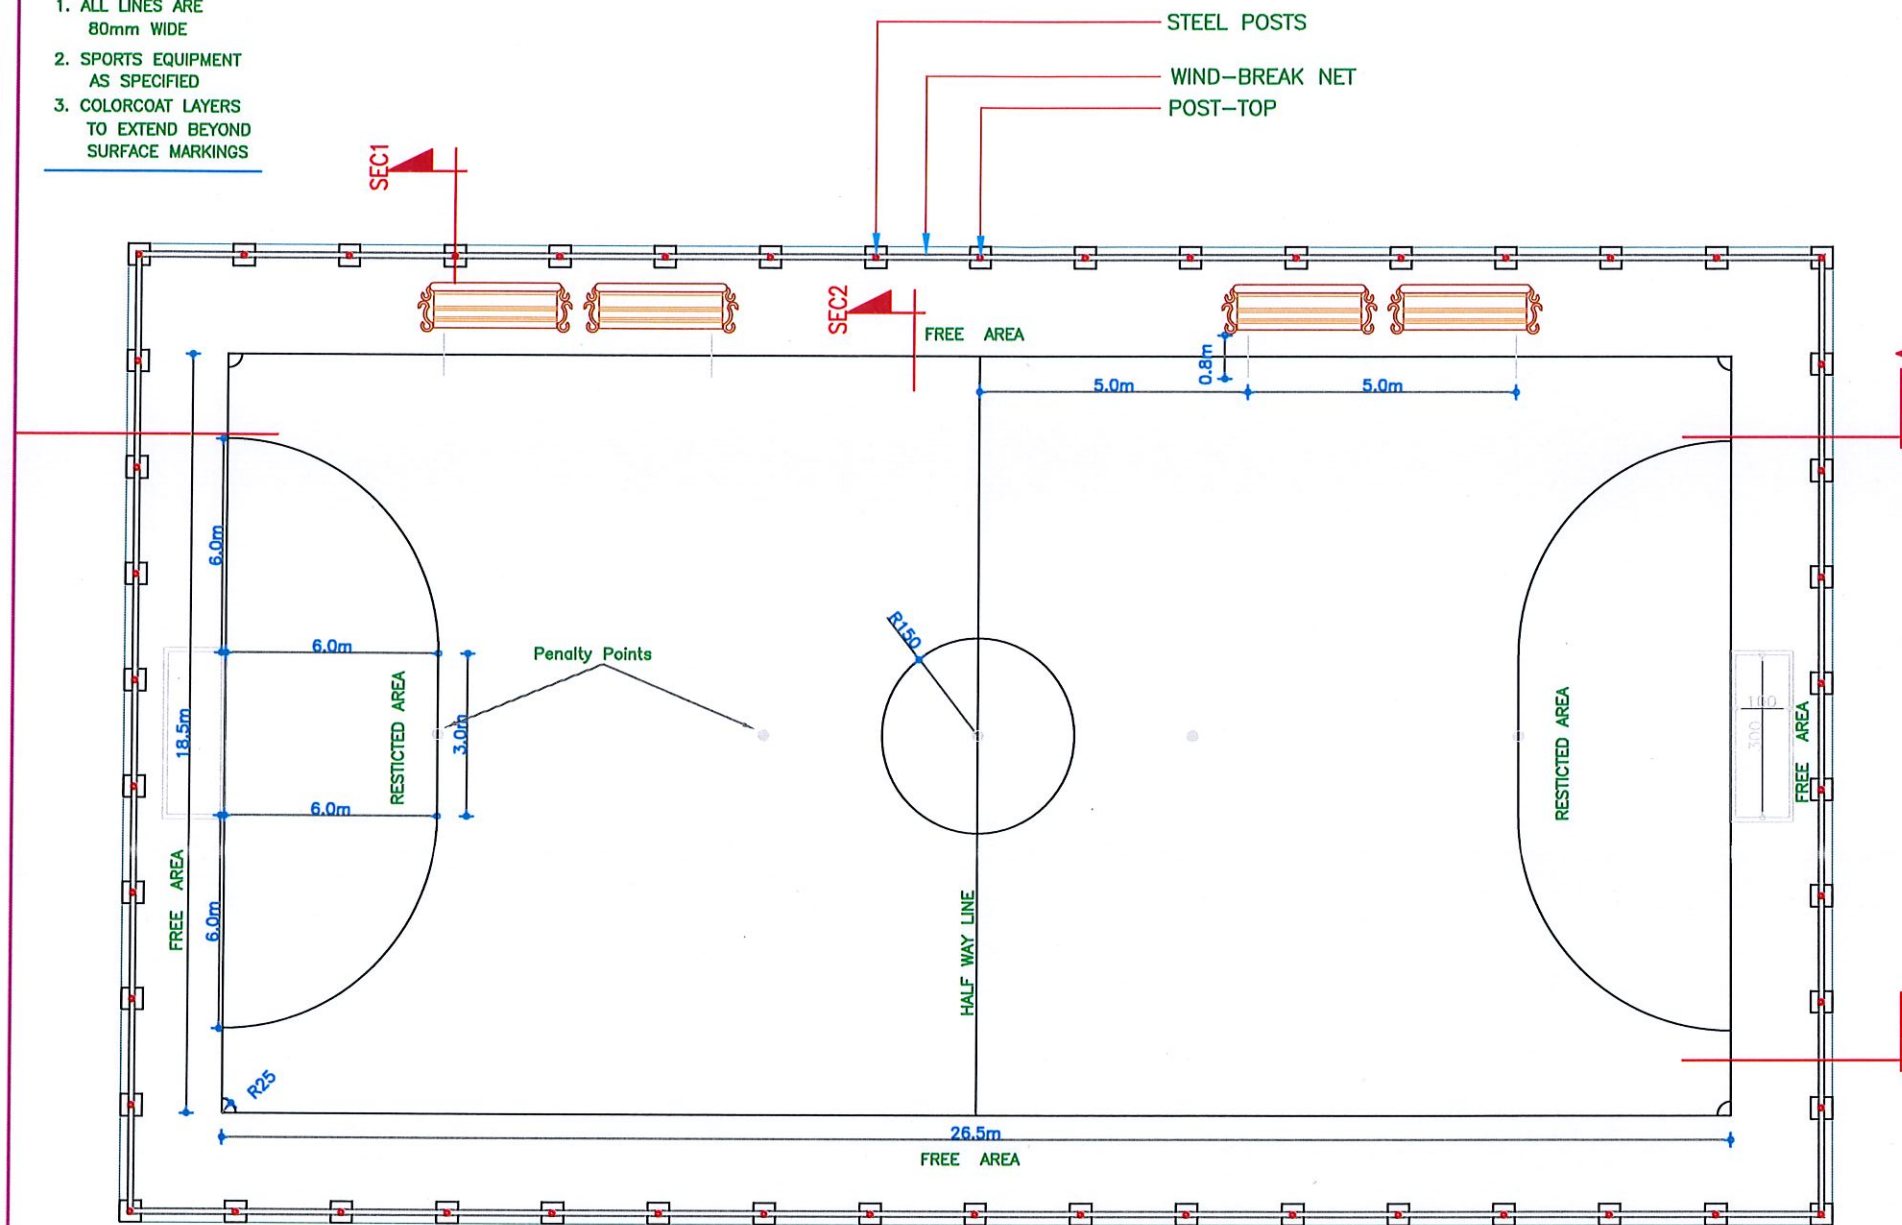


PLAN scale N.T.S

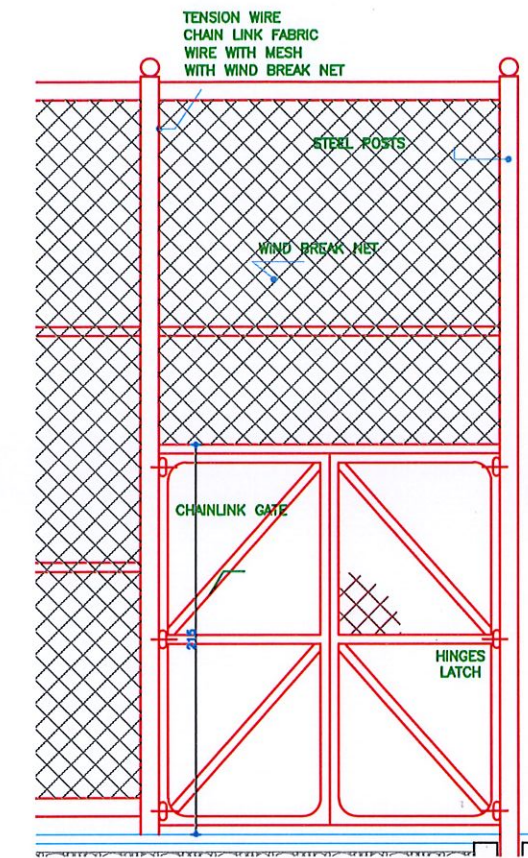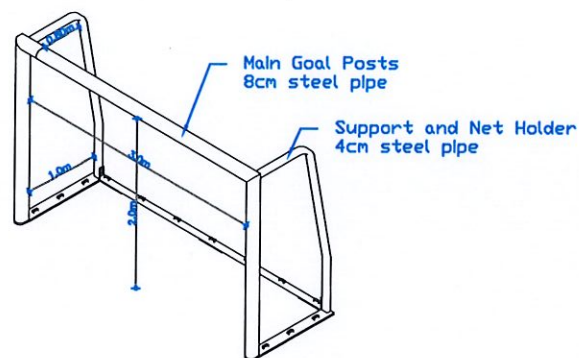

A- CHAIN LINK GATE

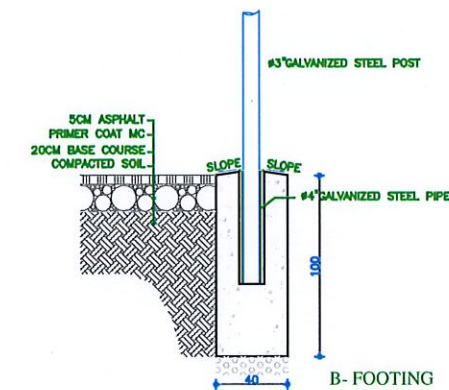

B- FOOTING

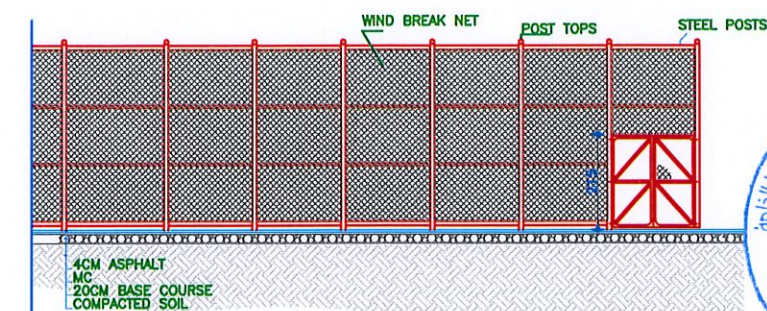

SECTION A-A

AQABA GARDENS PROJECT
AQABA - JORDAN



SUBOH
CONSULTING
ENGINEERS
AMMAN - JORDAN

PHONE 5665789
P.O.BOX 2075
e:mail rasobeh@nol.com.jo
FAX 5661541

PRODUCED BY :
SIGNATURE









DESIGNED BY :
SIGNATURE

APPROVAL
CHECKED BY :
SIGNATURE

AQABA
GARDENS-PROJECT



DATE : NOVEMBER-2006
SCALE : VARIES
DRAWING NUMBER : AD-006 LAND NO. :

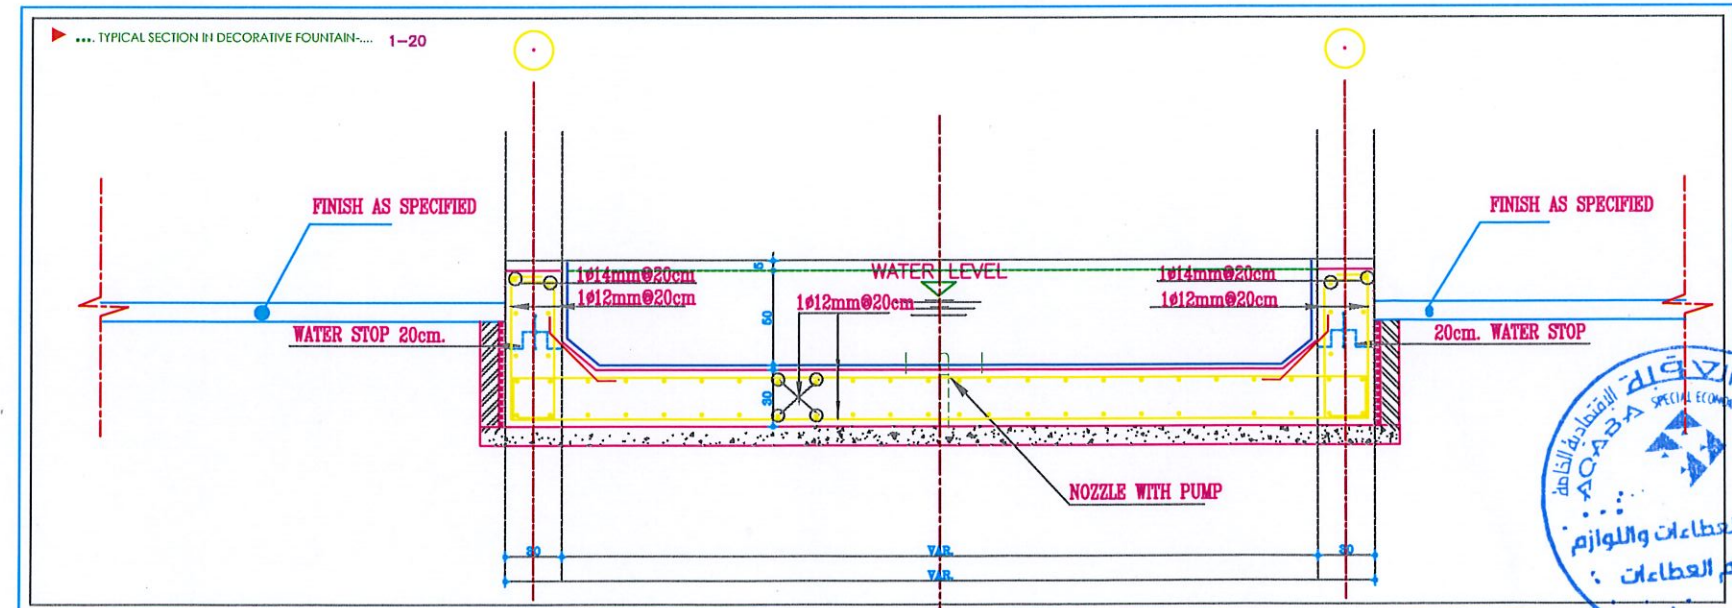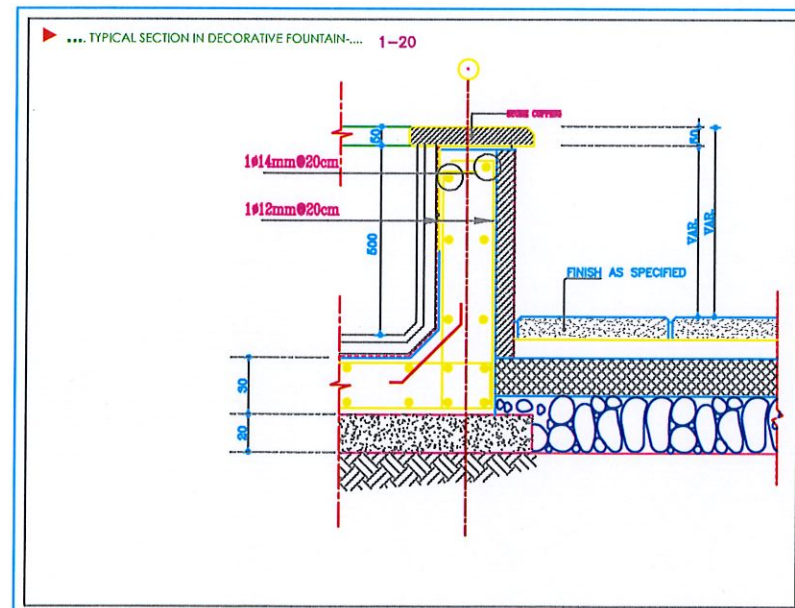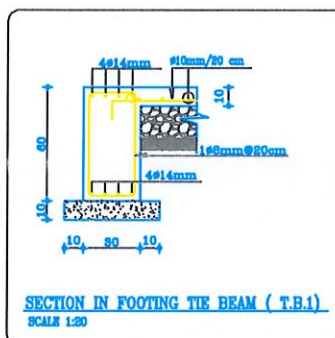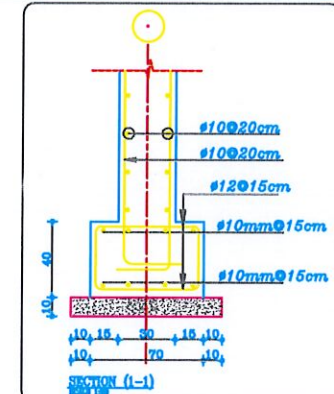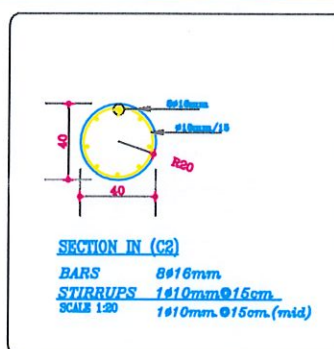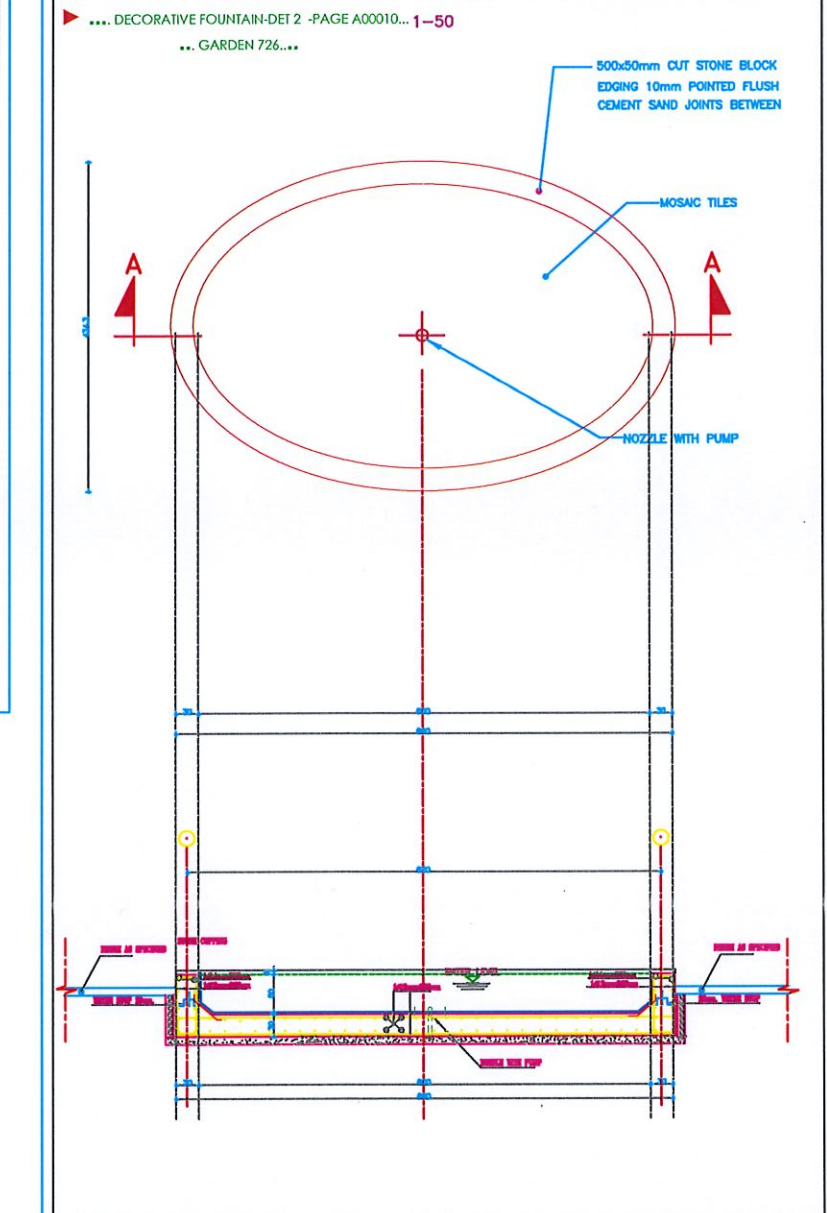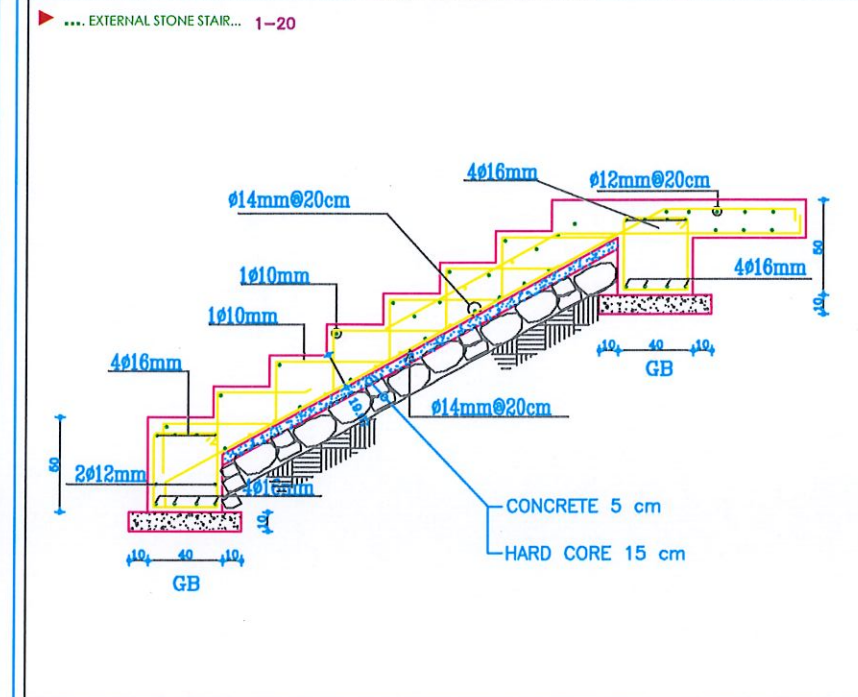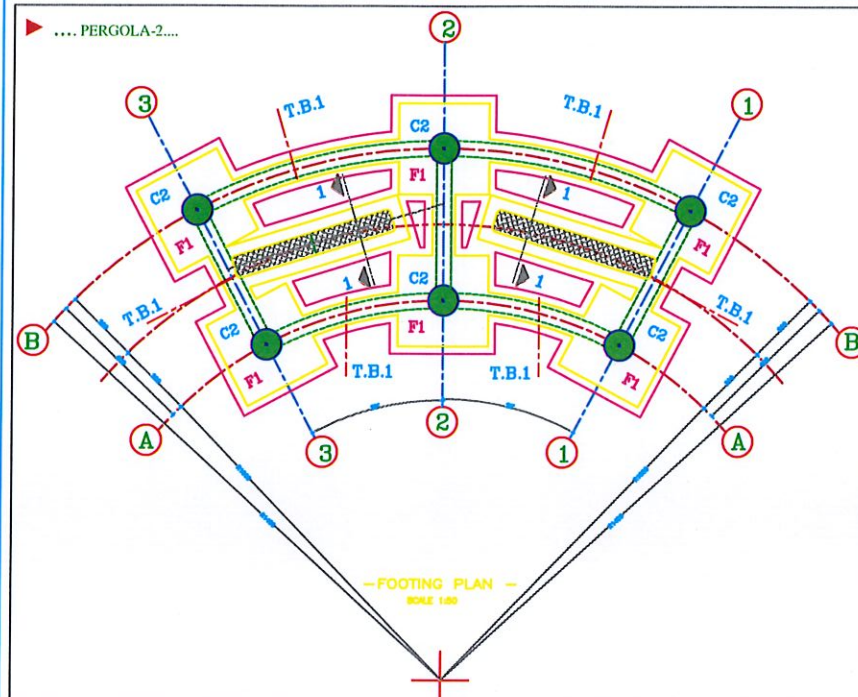

AQABA GARDENS PROJECT
AQABA - JORDAN

SUBOH CONSULTING ENGINEERS
AMMAN - JORDAN

PHONE 5665789
P.O.BOX 2075
e:mail rsobeh@nol.com.jo
FAX 5661541

PRODUCED BY : MUNA ANANEH
SIGNATURE

DESIGNED BY : NEDIA SA'ED
SIGNATURE

APPROVAL
CHECKED BY : ENG. NADIM DAQQAQ
SIGNATURE


AQABA GARDENS-PROJECT

DETAILS

SHEET
PERGOLA-2
DECORATIVE FOUNTAIN

PROJECT NO.

PHASE	THIRD
DATE	NOVEMBER-2006
SCALE	VAR.
DRAWING NUMBER	SD-001

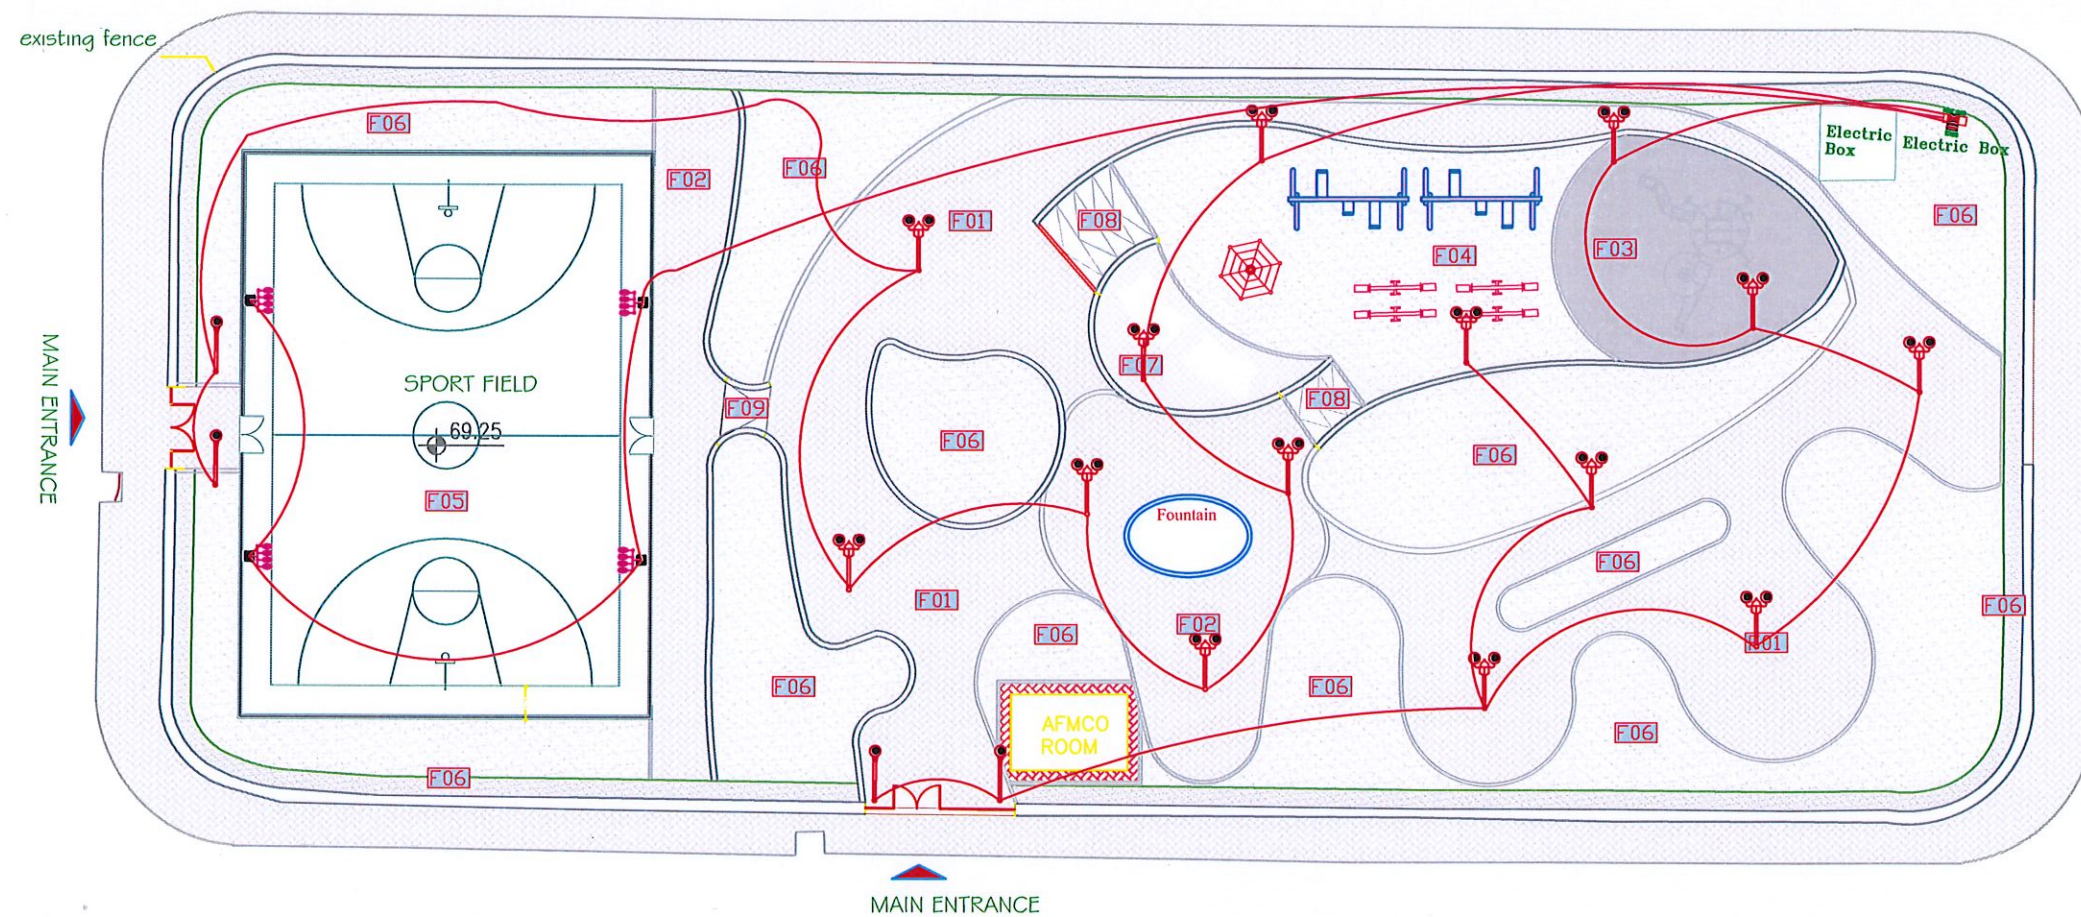

AQABA GARDENS PROJECT
AQABA - JORDAN



SUBOH
CONSULTING
ENGINEERS
AMMAN - JORDAN

PHONE 5665789
P.O.BOX 2075
e:mail rsobeh@nol.com.jo
FAX 5661541

PRODUCED BY: ENO. KHALED A'AMAR
SIGNATURE

DESIGNED BY: ENO. KHALED A'AMAR
SIGNATURE

APPROVAL
CHECKED BY: ENO. JALAL DAHMOUD
SIGNATURE

AQABA
GARDENS-PROJECT



PLANS

SHEET

ELECTRICAL INSTALLATION

PLAN OF GARDEN # 140

PROJECT NO.


DATE

SCALE

DRAWING NUMBER

LAND NO. :

140

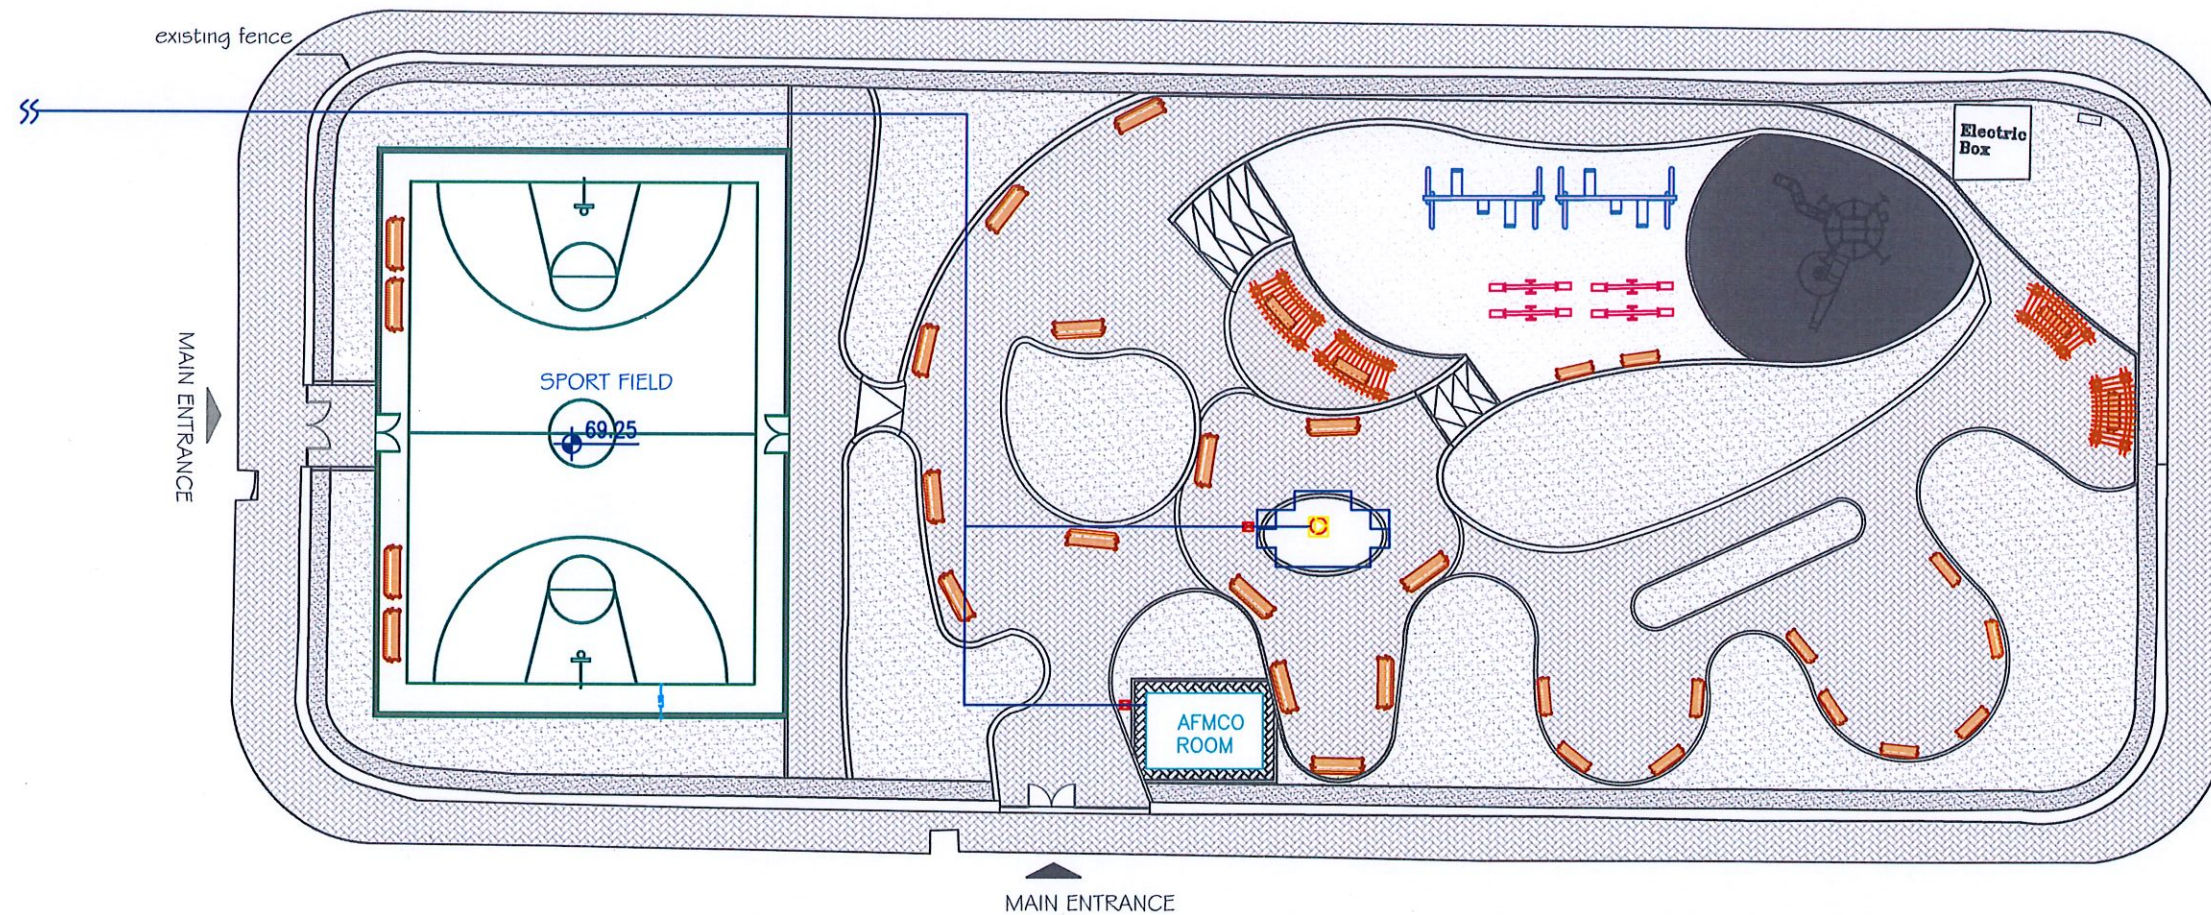

**SUBOH
CONSULTING
ENGINEERS**
AMMAN - JORDAN

PHONE 5665789
P.O.BOX 2075
e:mail rsobeh@nol.com.jo
FAX 5661541

PRODUCED BY :
SIGNATURE

DESIGNED BY :
SIGNATURE


APPROVAL
CHECKED BY :
SIGNATURE

**AQABA
GARDENS-PROJECT**

SHEET
WATER PLANS

SCALE 1/200
DRAWING NUMBER M-001 LAND NO. 140



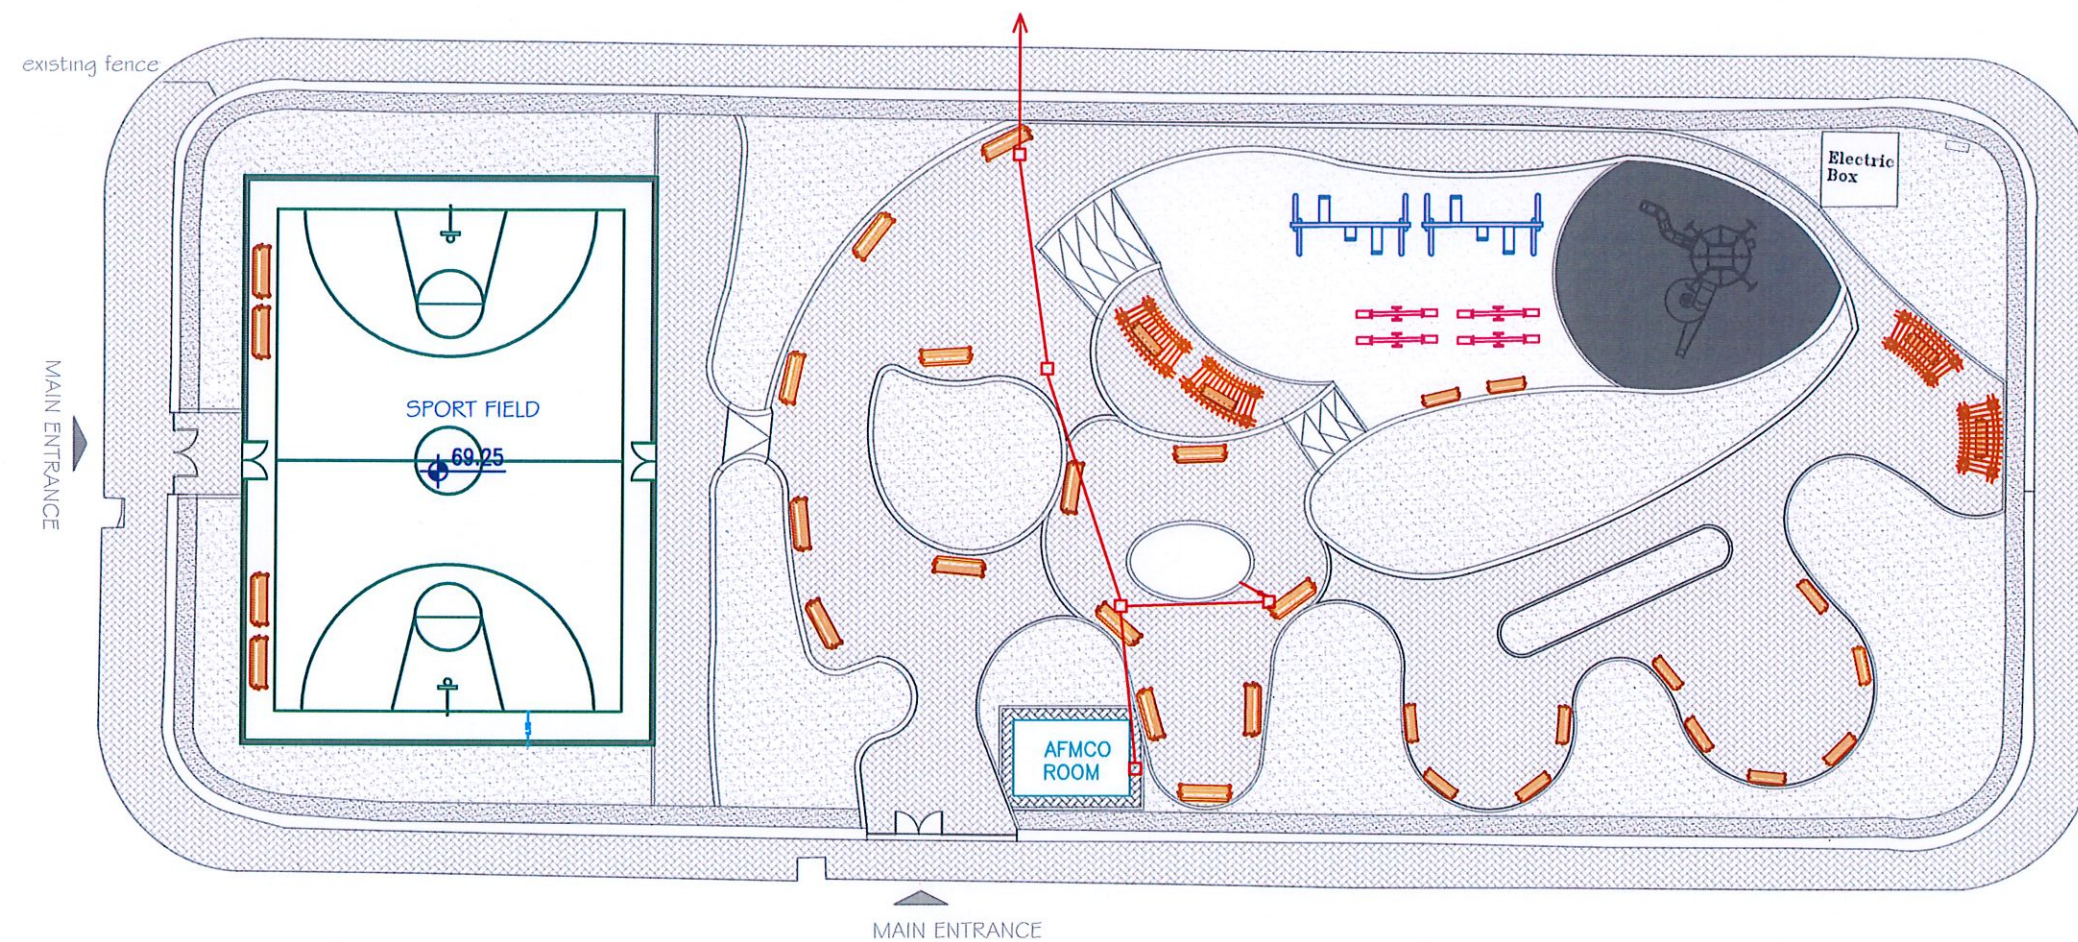

SUBOH CONSULTING ENGINEERS
AMMAN - JORDAN

PHONE 5665789
P.O.BOX 2075
e:mail rsobeh@nol.com.jo
FAX 5661541

PRODUCED BY :
SIGNATURE
DESIGNED BY :
SIGNATURE
APPROVAL
CHECKED BY :
SIGNATURE

AQABA GARDENS-PROJECT



SCALE
DRAWING NUMBER M-002
LAND NO. : 140